
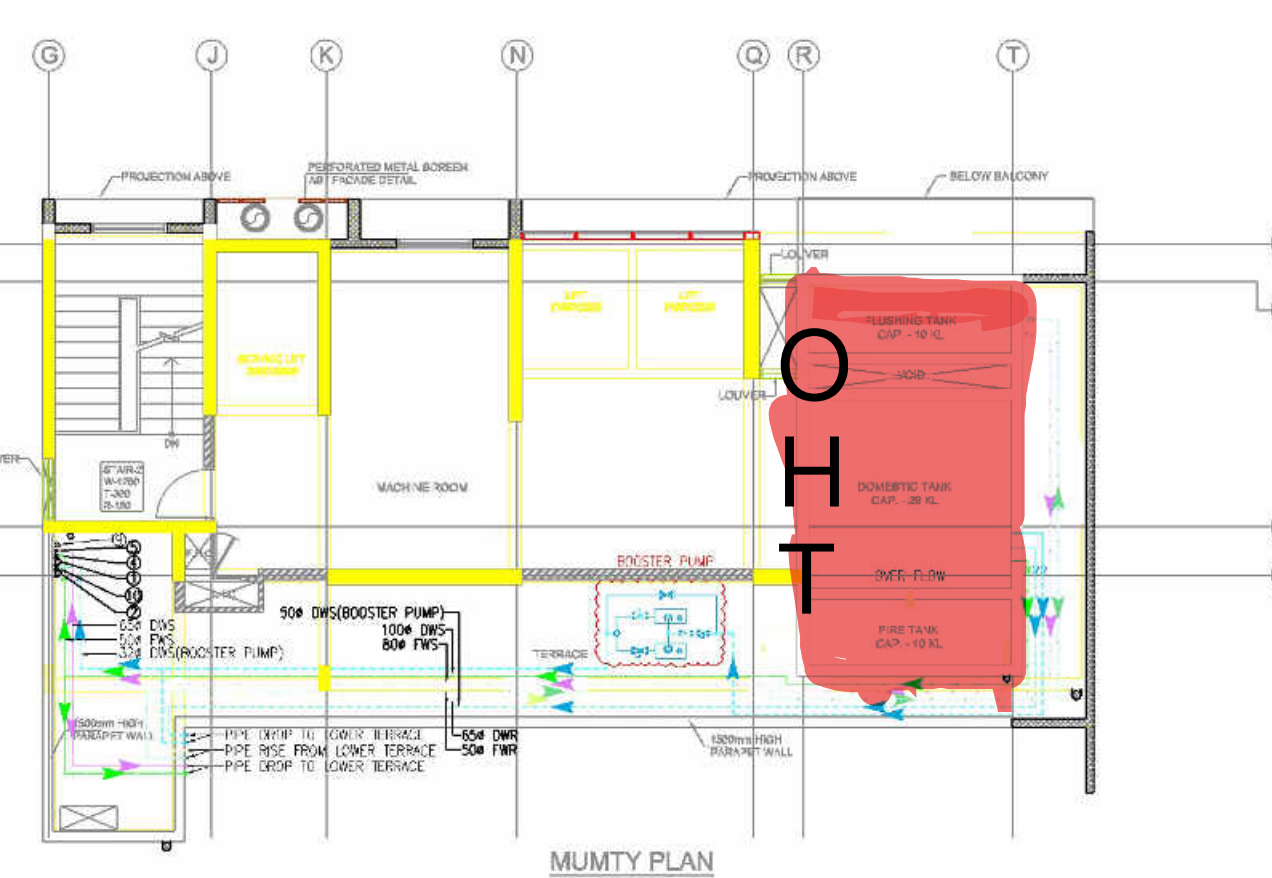
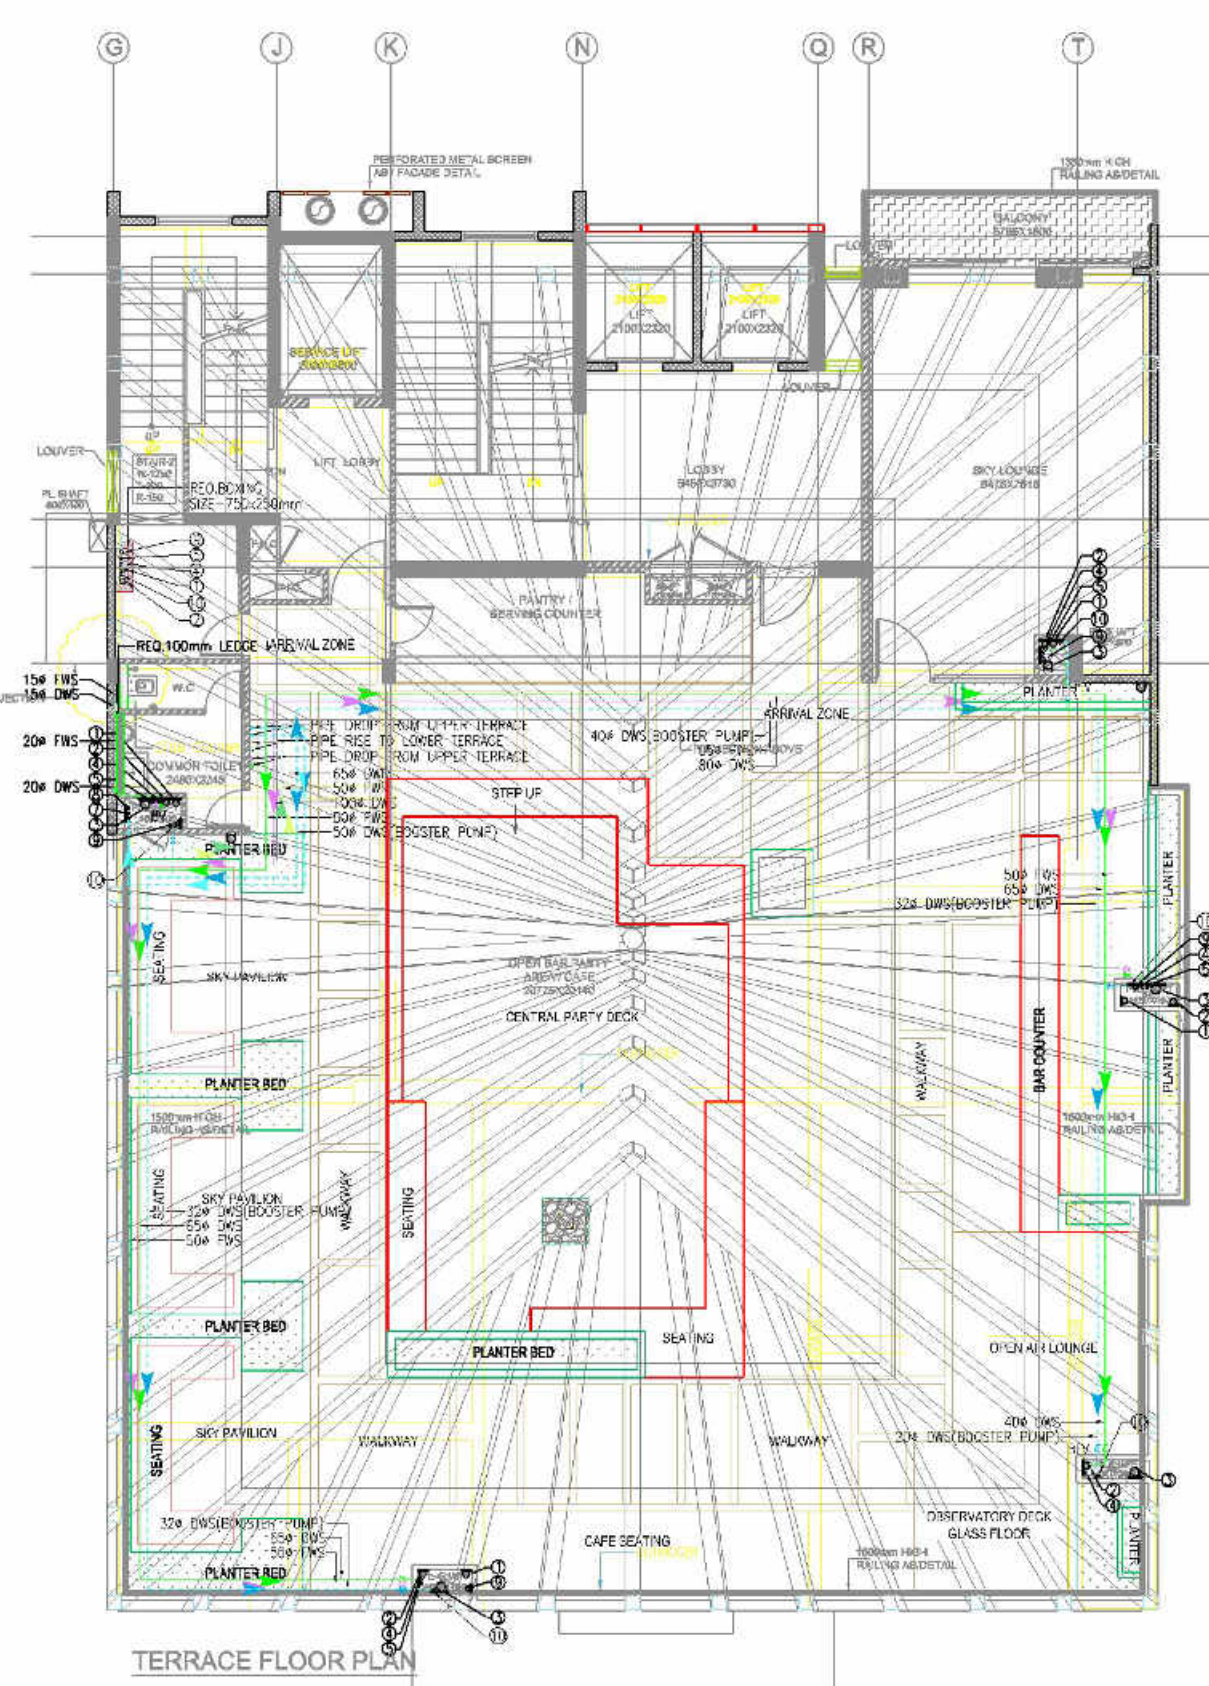
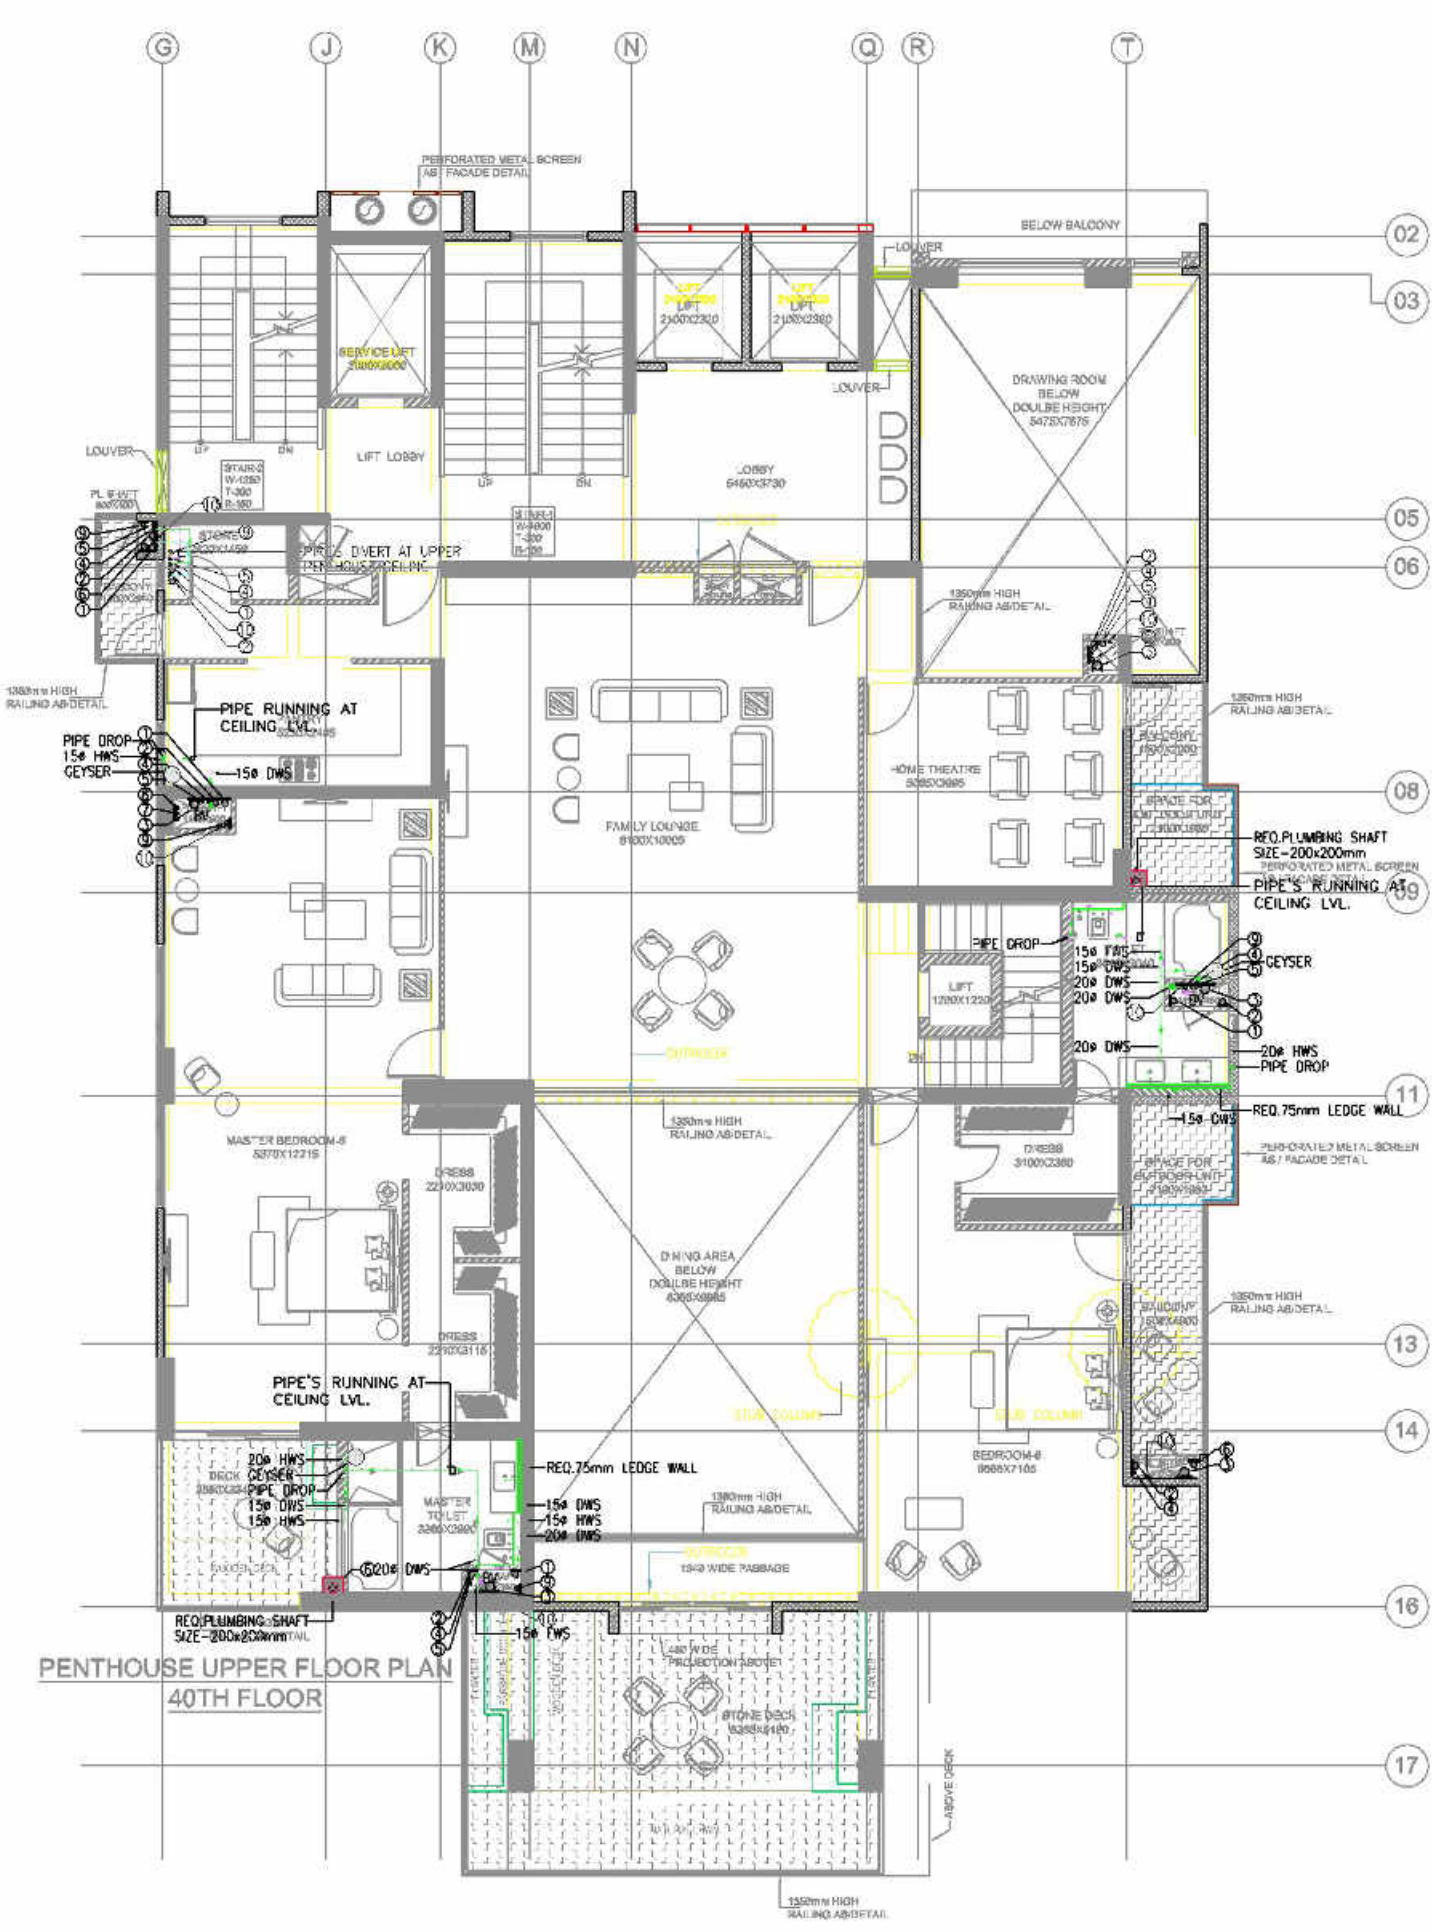
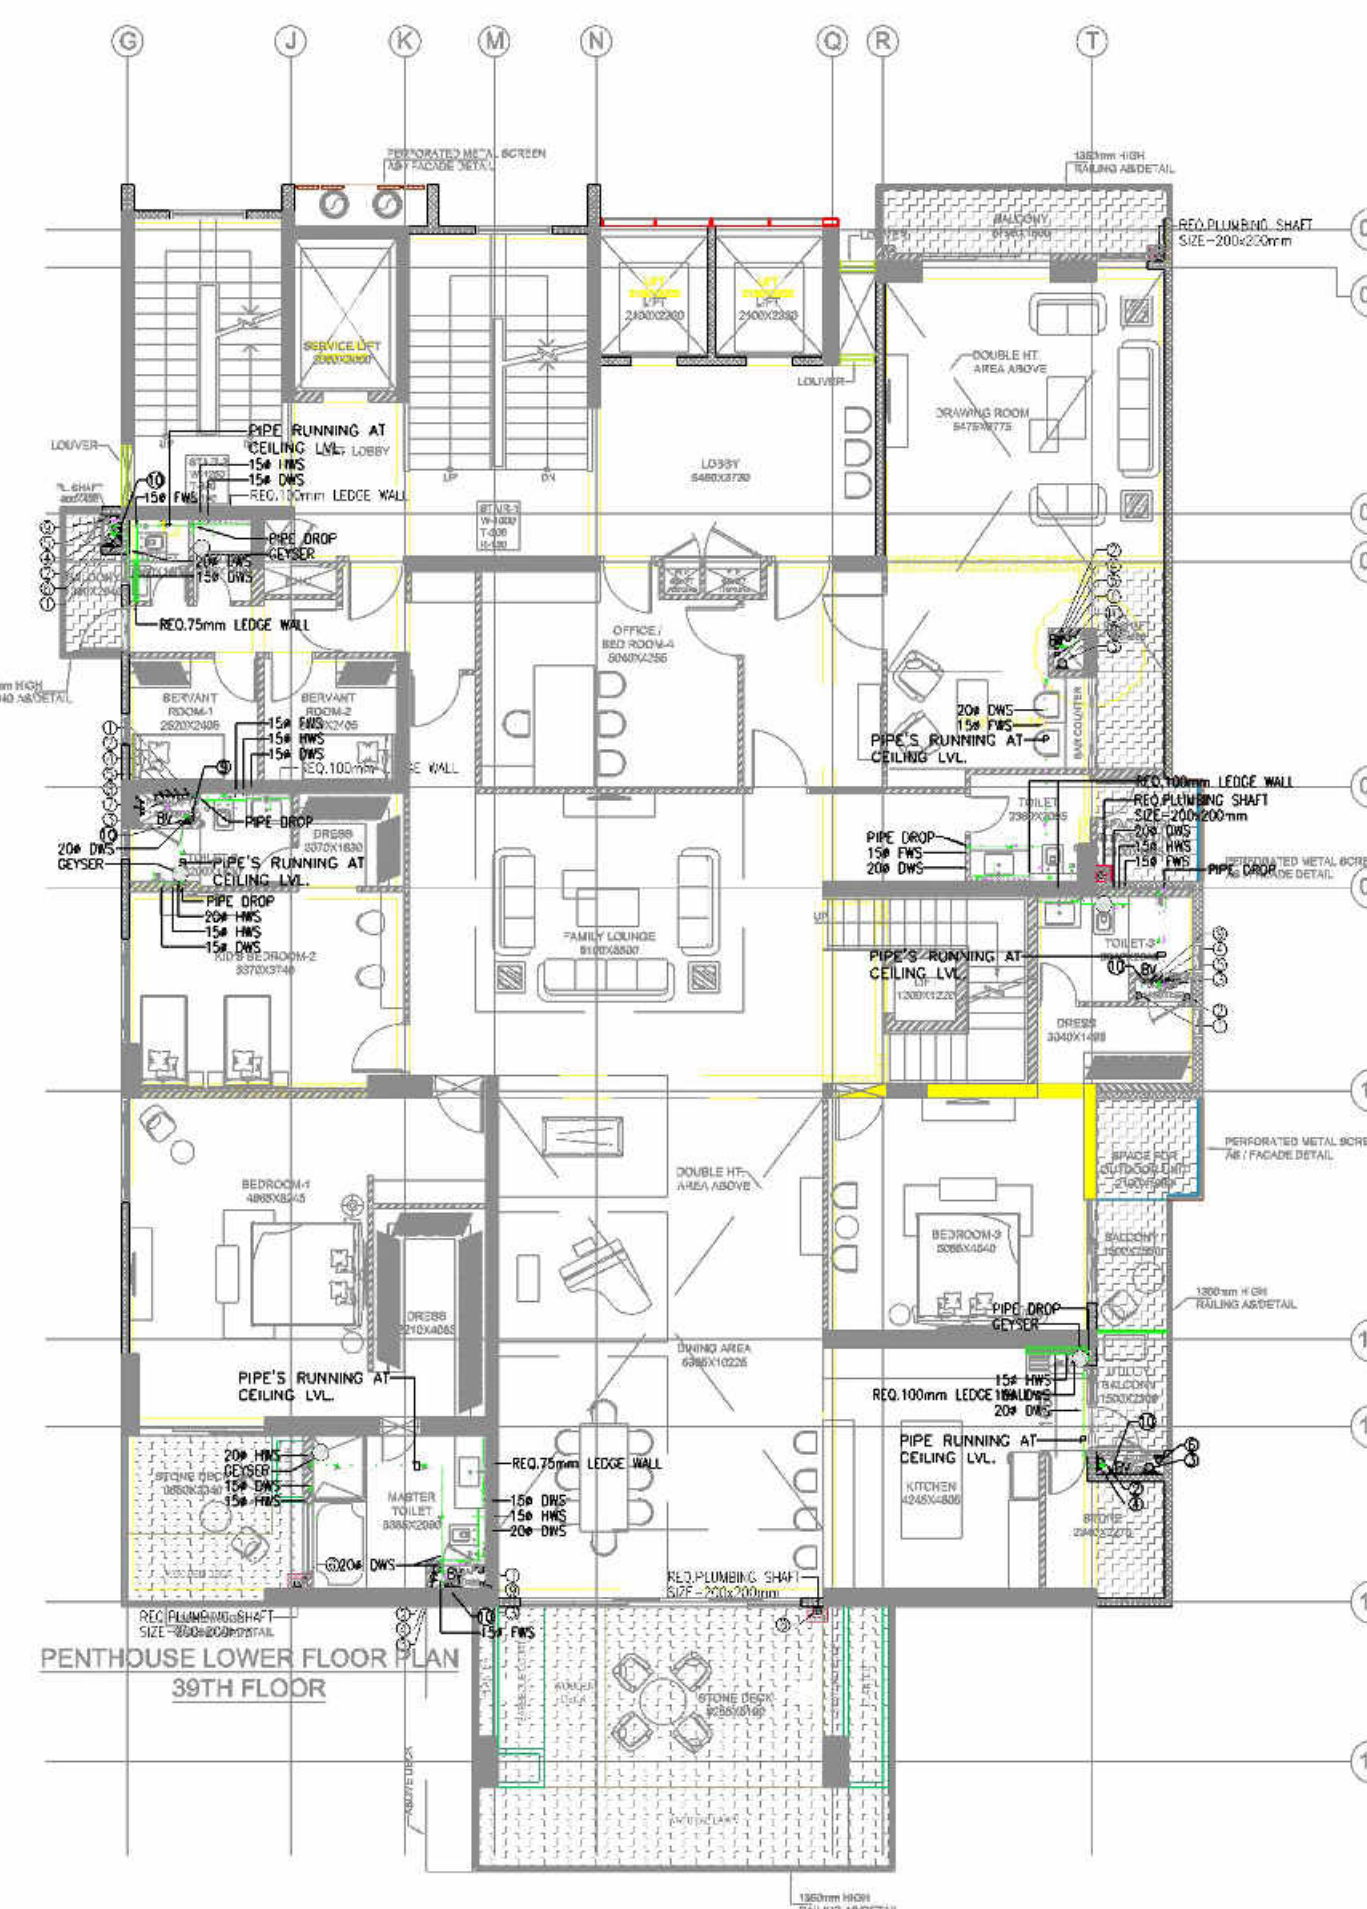
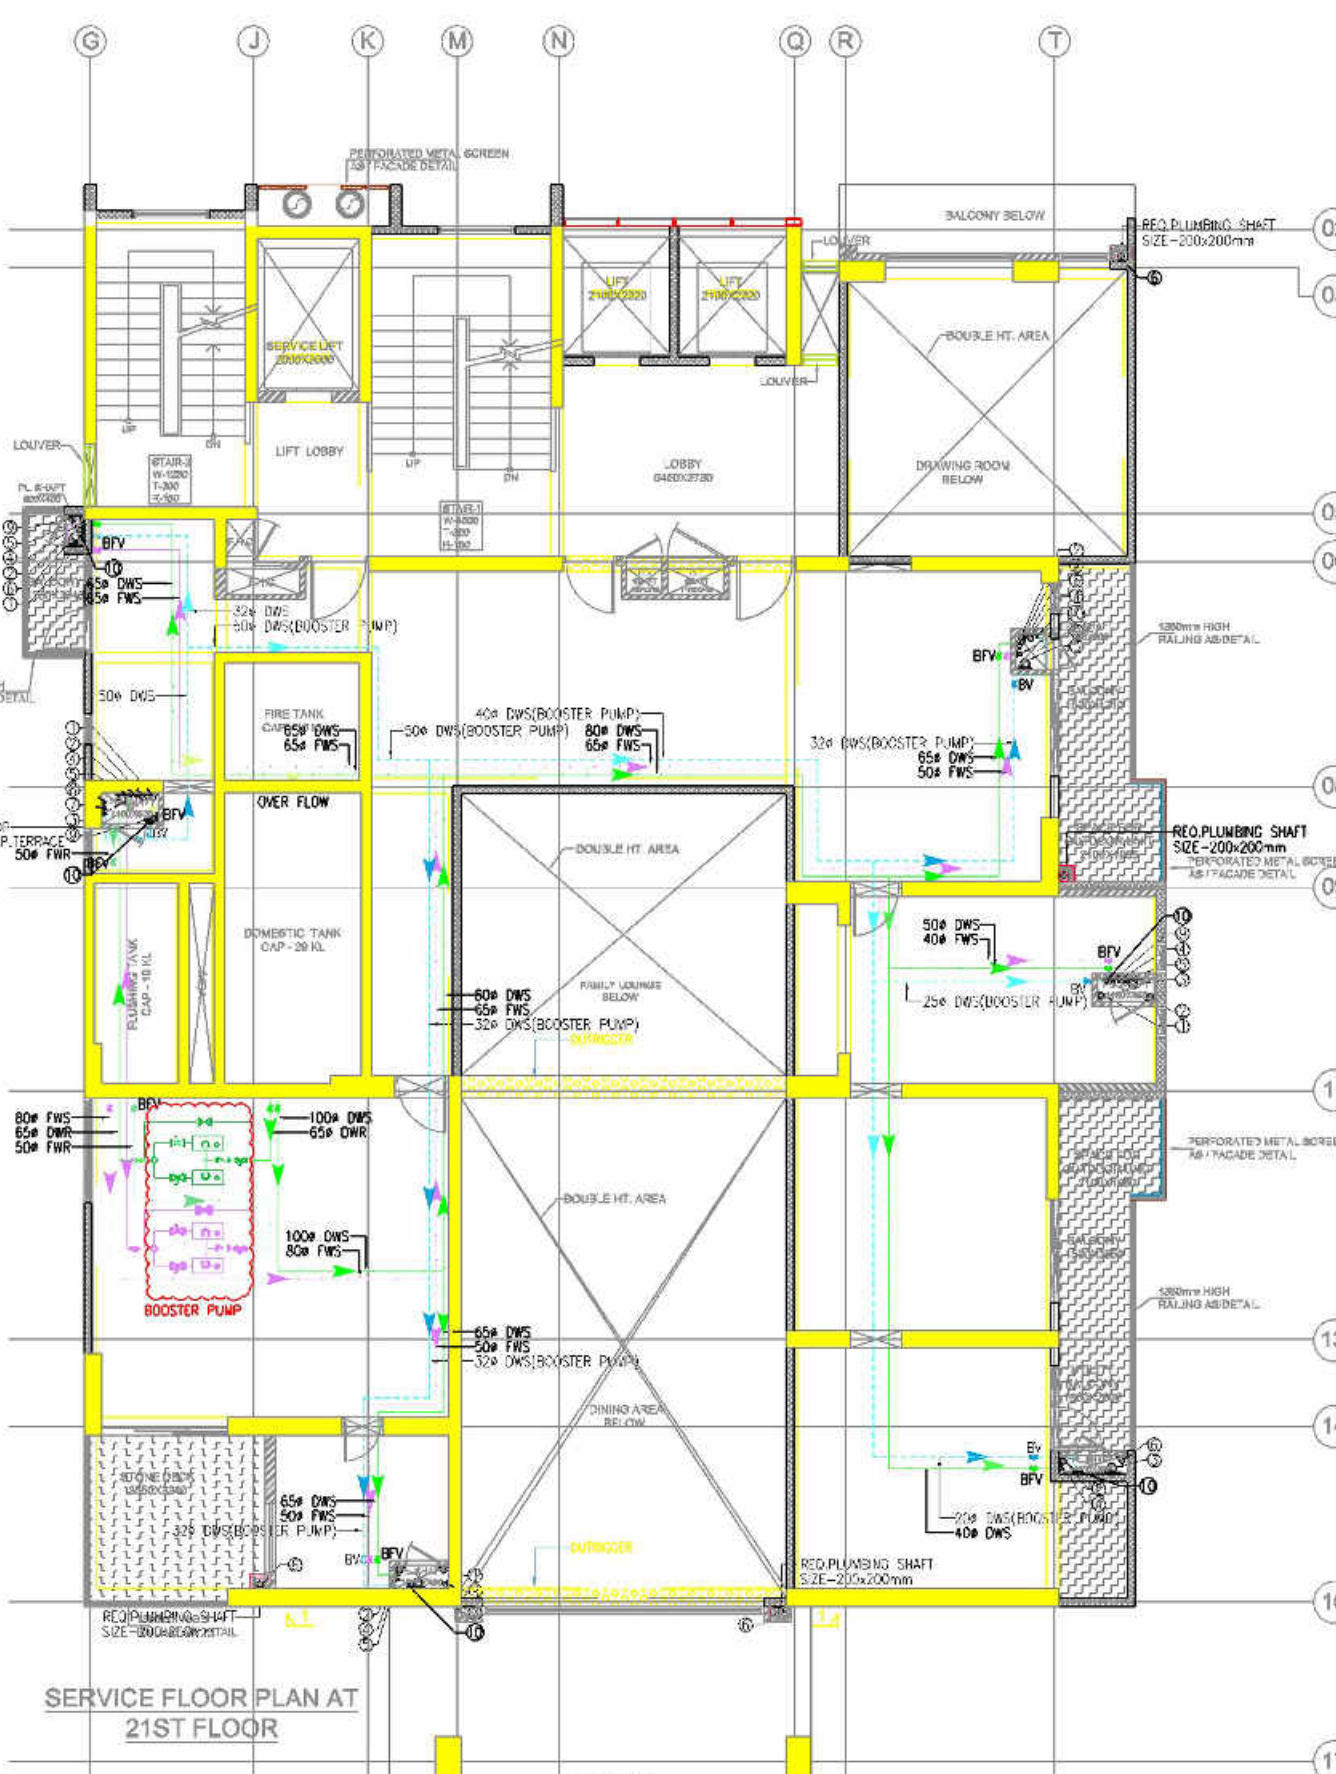


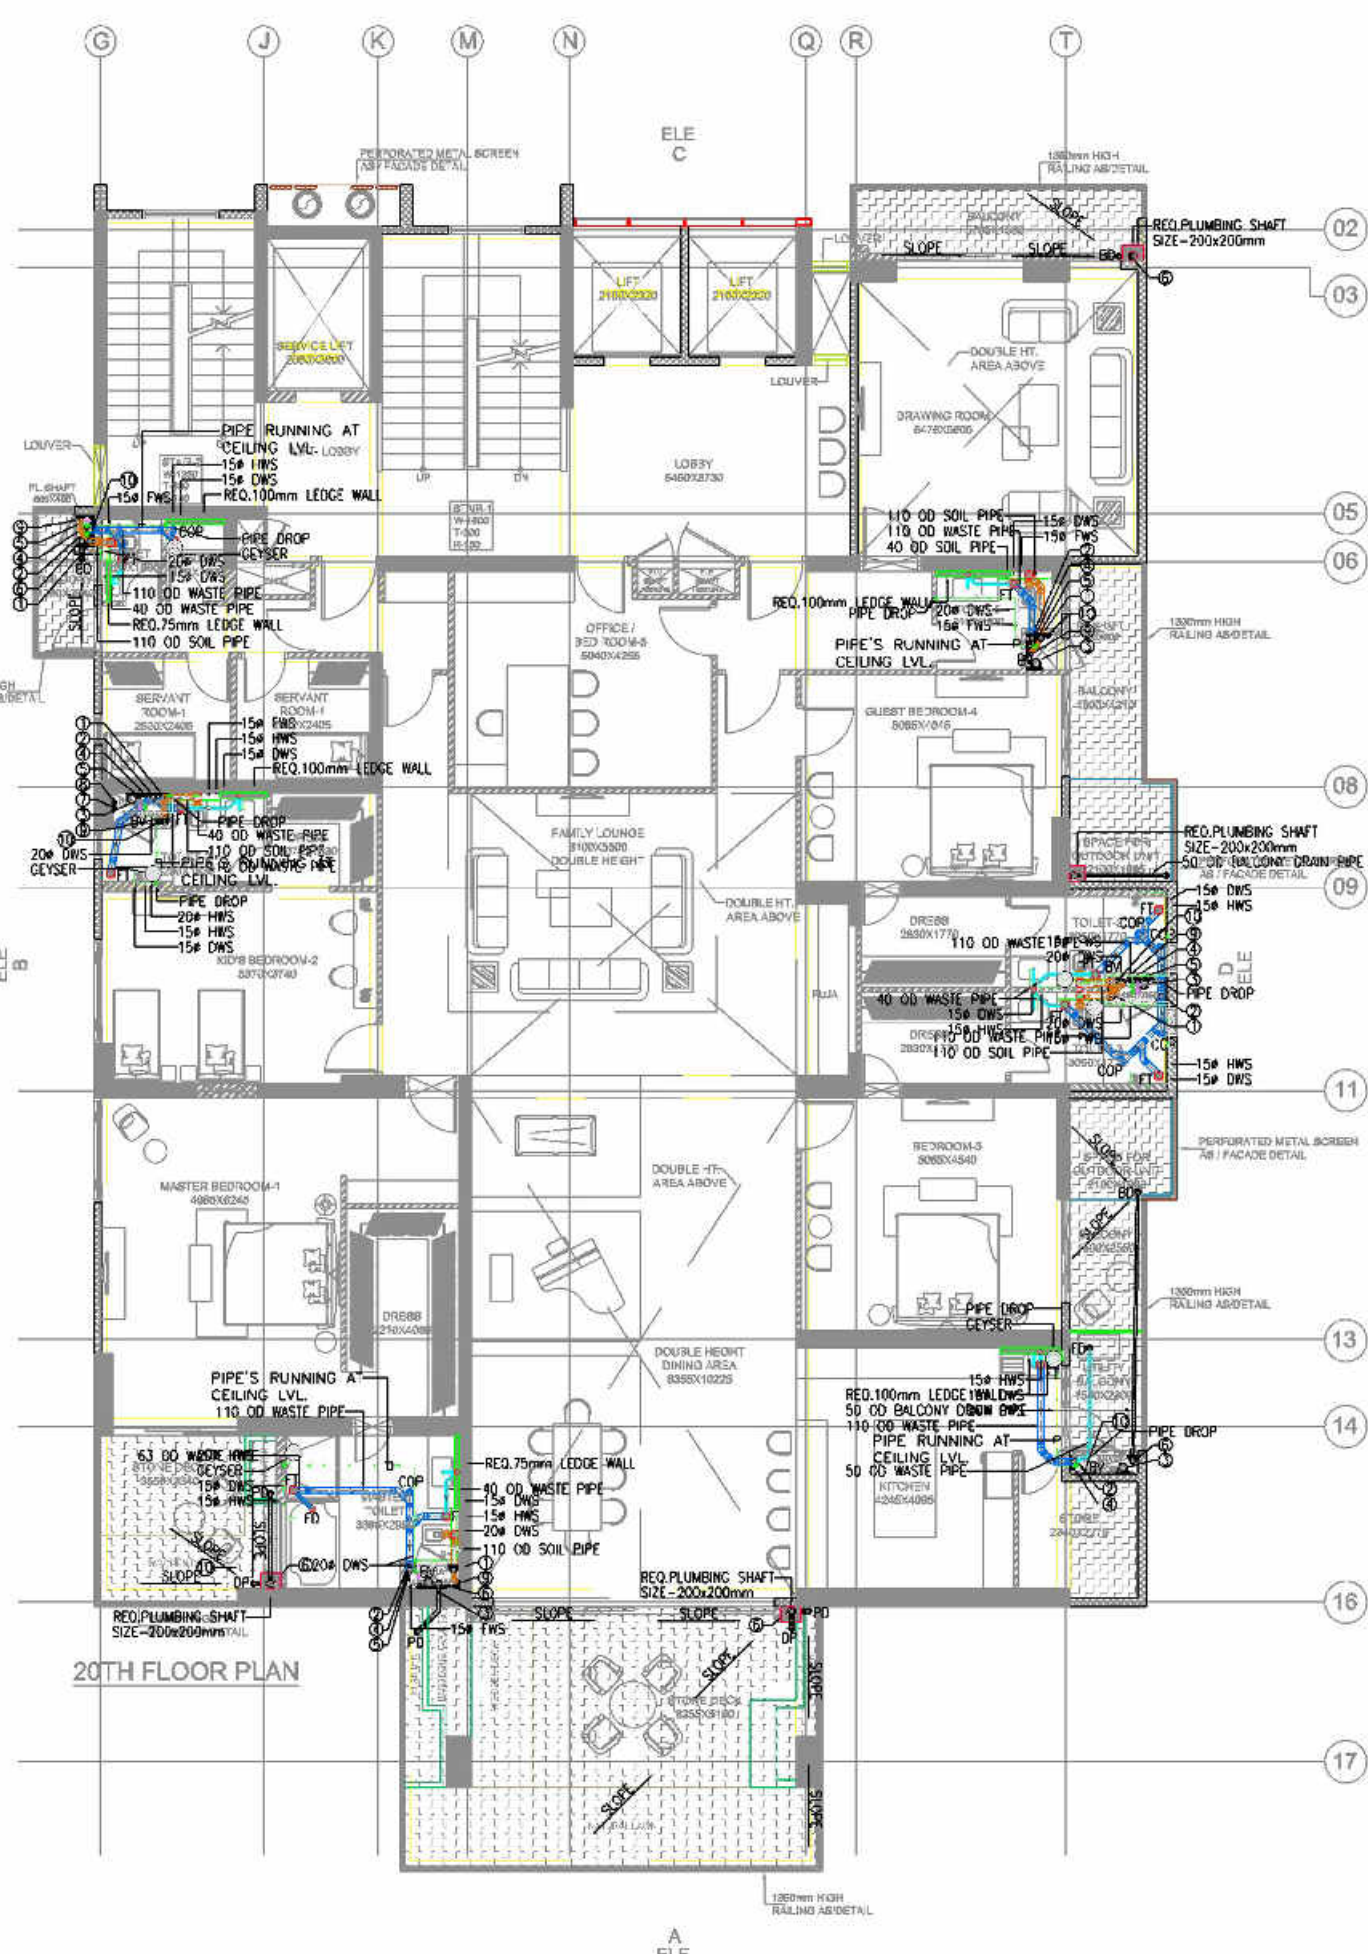

PLUMBING LEGEND:-			
①	110Ø SOIL PIPE		
②	110Ø WASTE PIPE		
③	160Ø RAIN WATER PIPE		
④	DWS DN TAKE PIPE		
⑤	FWS DN TAKE PIPE		
⑥	110Ø BALCONY DRAIN PIPE		
⑥a	75Ø BALCONY DRAIN PIPE		
⑦	65Ø DWS RISER		
⑧	50Ø FWS RISER		
⑨	75Ø VENT PIPE		
⑩	DWS FROM BOOSTER PUMP FOR TOP TWO FLOOR		
⑩	100Ø DRAIN PIPE FOR BASEMENT'S		
D	DOMESTIC WATER RISER PIPE		
DWR	FLUSHING WATER RISER PIPE		
FWR	DOMESTIC WATER SUPPLY PIPE		
DWS	FLUSHING WATER SUPPLY PIPE		
FWS	HOT WATER SUPPLY PIPE		
HWS	BOOSTER PUMP FOR TOP THREE FLOOR		

This drawing is a "COPYRIGHT" contents of this drawing or part thereof may not be used or reproduced without the permission of the Architect

NORTH POINT			
NO. OF PRINTS	DATE	ISSUED TO	REMARKS
REVISION	DATE	DESCRIPTION	BY

CUSTOMER
PRESTIGIA DEVELOPERS LLP

PROJECT
RESIDENTIAL AT GOMTI NAGAR EXTN. LUCKNOW

DESIGN DEVELOPMENT DRAWING

DATE	DEALT BY	CHECKED BY
DECEMBER- 2023	SANTOSH	PRAMOD
SCALE	PROJECT ARCHITECT	APPROVED BY
1:150	SUBODH KUMAR	YASHVEER SINGH

DRAWING TITLE
20TH.SERVICE FLOOR PLAN,
PENT HOUSE PLANS
TERRACE AND ROOF PLAN
WATER SUPPLY LAYOUT

ARCHITECTS:-
C. P. KUKREJA ARCHITECTS
ASHIRWAD BUILDING
D-1, GREEN PARK,
NEW DELHI - 110016,
PHONE:- 26863953 FAX:- 26865770,
EMAIL:-cpka@cpkukreja.com

DRAWING NO.	REVISION
845-PDL-DD-P-WS-FP39A & FP40A	R0