

THIS DRAWING IS CONFIDENTIAL AND SHOULD NOT BE DISCLOSED COPIED OR LENT TO A THIRD PARTY WITHOUT WRITTEN CONSENT OF SKYLINE ARCHITECTURAL CONSULTANTS. EXCEPT THE SYSTEM FOR WHICH THE DRAWING IS MEANT.

DO NOT SCALE DRAWING ONLY WRITTEN DIMENSIONS ARE TO BE FOLLOWED

MEP CONSULTANT:



SYSTEM CONSULTANCY SERVICES
I - 1/79, 1st. Floor, Sector 16, Rohini, Delhi
22, Ravindra Enclave, Ravindra Palli, Lucknow
Email: design@systemconsultancyserives.com

[illegible]

CLIENT

THE AINSBACH SQUARE AT MILL ROAD LICKNOM

ARCHITECT



SKYLINE
INFRAWORLD PVT. LTD

OFFICE : 11th FLOOR, LAXMI VARDAN COMMERICAL COMPLEX AT PARAKRASHI RAM CROSSING, GOAMTINAGAR, LUCKNOW, U.P. INDIA

PHONE : 0522-2394123,2393123,4044123 fax 0522-2393126

E-MAIL : sk@laxmivardanlknw.com


LECT. • SANJAY & VIJAY SINHA

ARCHITECT : SANJAY & VIJAY SINHA

TITLE	SCALE -	DATE
-------	---------	------

FILE
SITE PLAN
COORDINATED LAYOUT

DRAWING NO.	REV.
-------------	------

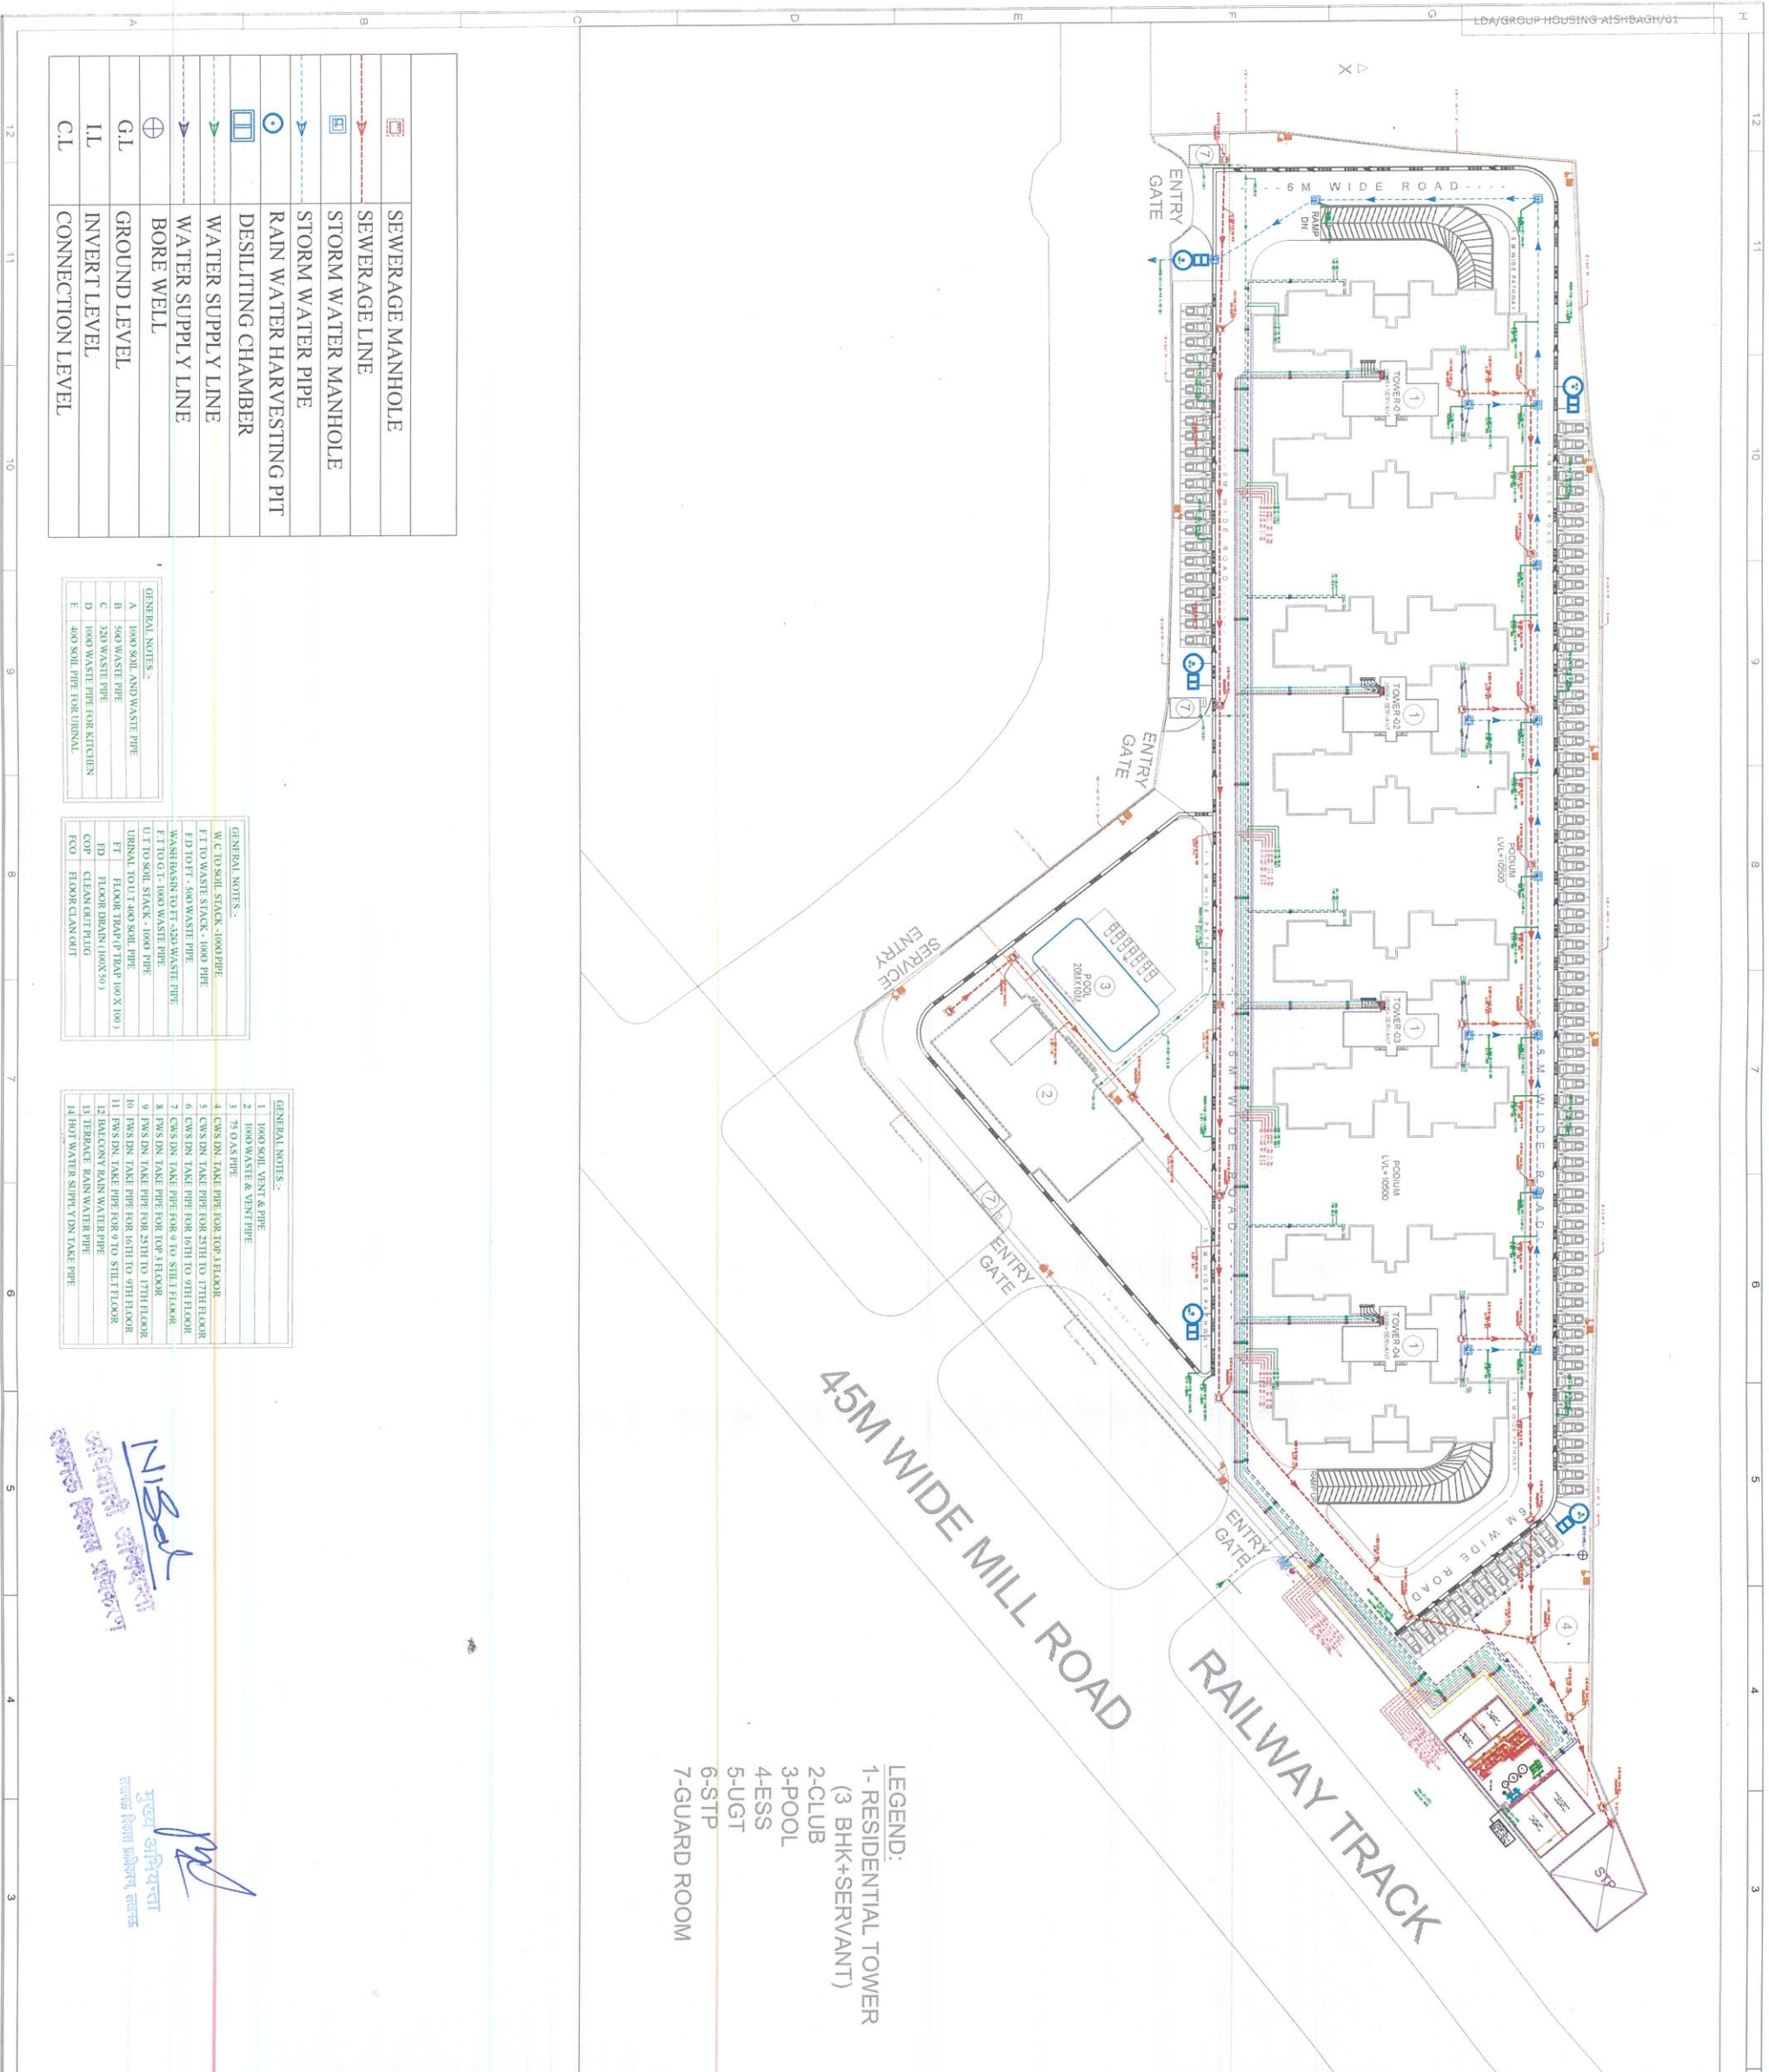

		SEWERAGE MANHOLE
		SEWERAGE LINE
		STORM WATER MANHOLE
		STORM WATER PIPE
		RAIN WATER HARVESTING PIT
		DESILTING CHAMBER
		WATER SUPPLY LINE
		WATER SUPPLY LINE
		BORE WELL
		GROUND LEVEL
		INVERT LEVEL
		CONNECTION LEVEL

GENERAL NOTES :-	
A	1000 SOIL AND WASTE PIPE
B	500 WASTE PIPE
C	320 WASTE PIPE
D	1000 WASTE PIPE FOR KITCHEN
E	400 SOIL PIPE FOR URINAL

GENERAL NOTES:-	
W.C. TO SOIL STACK - 1000 PIPE	
F.T TO WASTE STACK - 1000 PIPE	
FD TO FT - 800 WASTE PIPE	
WASHBASIN TO FT - 320 WASTE PIPE	
F.T TO S.O.T - 1000 WASTE PIPE	
U.T TO SOIL STACK - 1000 PIPE	
URNAL TO U.T 400 SOIL PIPE	
FT	
FD	FLOOR TRAP (P TRAP 100 X 100)
FD	FLOOR DRAIN (100X 50)
COP	CLEAN OUT PLUG
FCO	FLOOR CLEAN OUT

GENERAL NOTES:-

1. 1000 SOIL VENT & PIPE
2. 1000 WASTE & VENT PIPE
3. 75 O.S PIPE
4. C.S.DN TANK PIPE FOR 3RD FLOOR
5. C.S.DN TANK PIPE FOR 3RD TO 5TH FLOOR
6. C.S.DN TANK PIPE FOR 5TH TO 7TH FLOOR
7. C.S.DN TANK PIPE FOR 7TH TO STILL FLOOR
8. P.S.DN TANK PIPE FOR TOP 3 FLOOR
9. P.S.DN TANK PIPE FOR 3RD TO 5TH FLOOR
10. P.S.DN TANK PIPE FOR 5TH TO 7TH FLOOR
11. P.S.DN TANK PIPE FOR 7TH TO STILL FLOOR
12. BALCONY RAIN WATER PIPE
13. TERRACE RAIN WATER PIPE
14. HOT WATER SUPPLY IN TANK PIPE

45M WIDE MILL ROAD

LEGEND:
1- RESIDENTIAL TOWER
(3 BHK+SERVANT)

7-GUARD ROOM

17/3/2021
संस्थान संकेत
संस्थान प्रमाण

मुख्य अभियन्ता
राज्यीय विमान मण्डल, लखनऊ