


OTHER'S PLOT

2100 MM HIGH BOUNDARY WALL

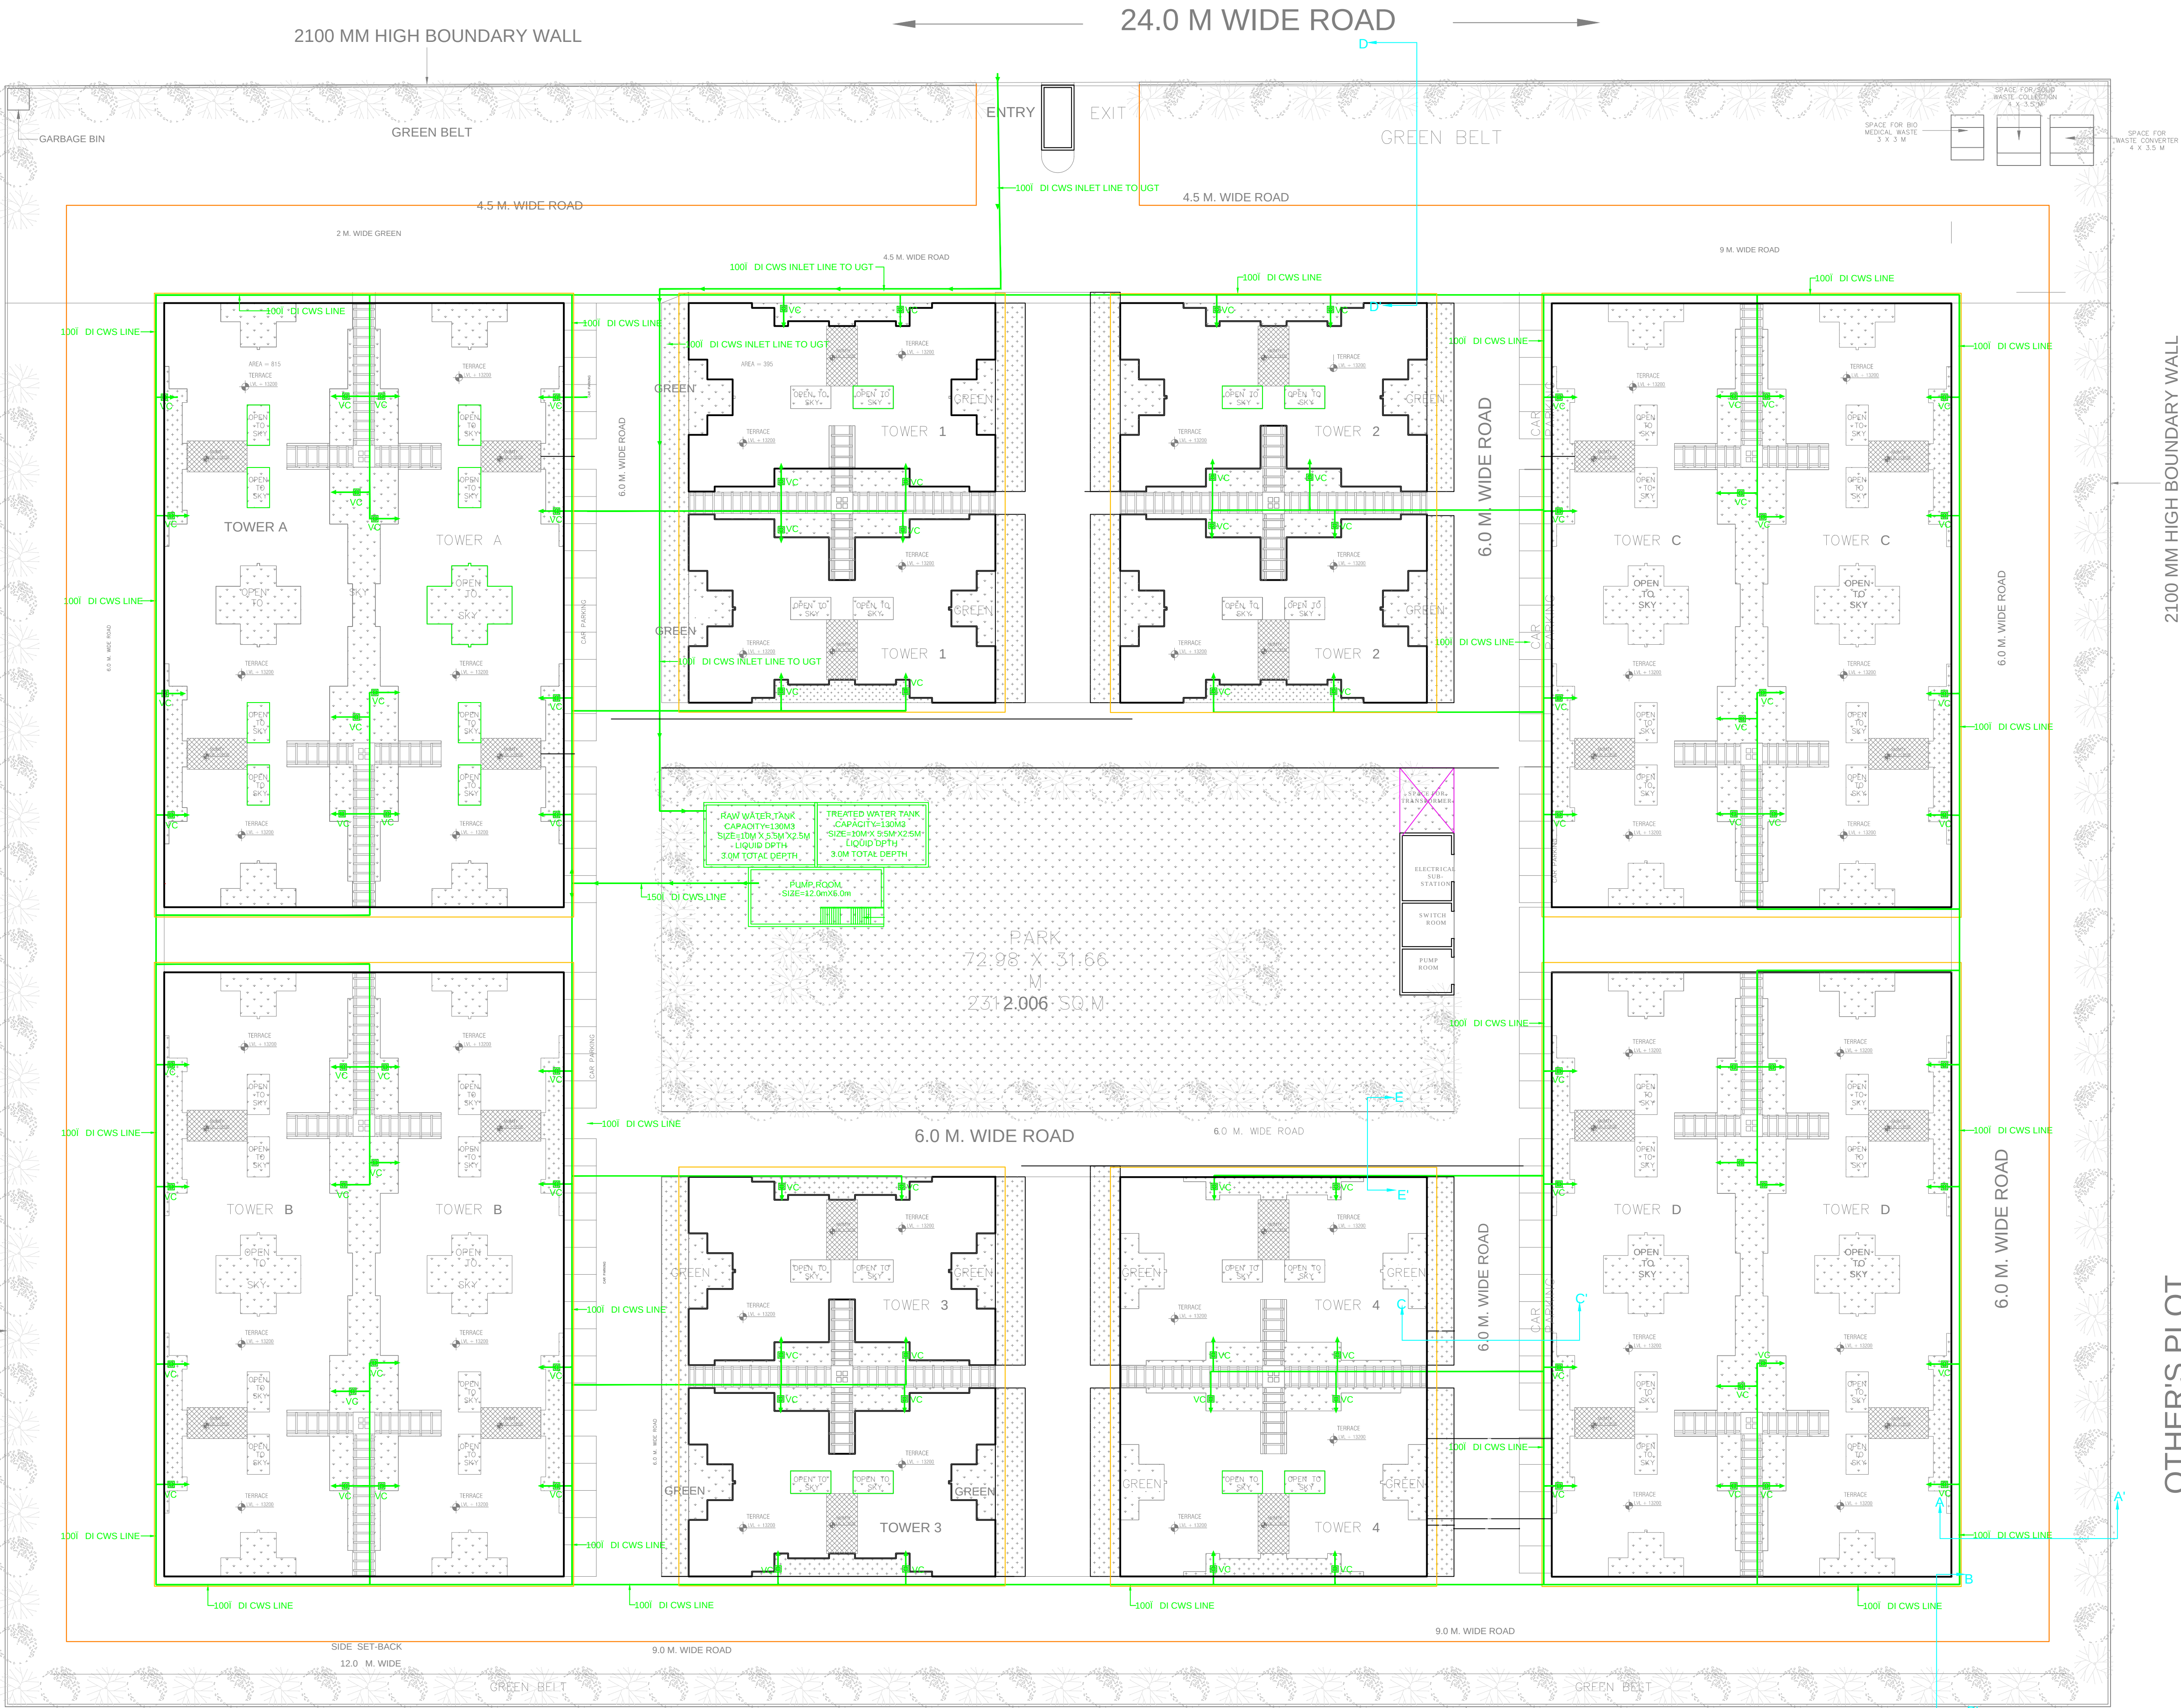

OTHER'S PROPERTY

2100 MM HIGH BOUNDARY WALL

SITE PLAN

WORKING DRAWING

- GENERAL NOTE**
1. THIS DRAWING IS THE COPYRIGHT OF THE ARCHITECTS, Ms. DEXTEROUS DESIGNERS & ASSOCIATES, GREATER NOIDA. SHOULD NOT BE REPRODUCED OR REPEATED WITHOUT THE PERMISSION OF THE ARCHITECT.
 2. THE CONTRACTOR MUST VERIFY ALL THE DIMENSSIONS AT SITE BEFORE COMMENCEMENT OF THE WORK AND REPORT DISCRIPNCEIS IF ANY TO THE ARCHITECTS.
 3. ALL WRITTEN DIMENSSIONS ARE TO BE READ AND NOT MEASURED.
 4. DRAWING SHALL BE APPROVED BY THE LOCAL BODY BEFORE COMMENCEMENT OF WORK AT SITE. ARCHITECT WILL NOT BE RESPONSIBLE FOR SUCH TYPE OF CONSTRUCTION.

LEGEND :		
S. No.	SYMBOL	DESCRIPTION
1.	VC	VALVE CHAMBER
2.	—	DI DOMESTIC WATER LINE

PROJECT :
CONSTRUCTION OF 382 Nos. RESIDENTIAL FLATS, FOUR STORIED ON PLOT NO. GH-01A/1, SECTOR-ETA-II, GREATER NOIDA. SUPER AREA 86.92 SQ.M.

ARCHITECT :
DEXTEROUS DESIGNERS & ASSOCIATES
architects, interior designers & urban planners
f-10/d-2, krishna apra royal plaza
alpha commercial belt, alpha-1,
greater noida.

CLIENT :
G.M. PLANNING AND ARCHITECTURE,
GREATER NOIDA INDUSTRIAL DEVELOPMENT
AUTHORITY
H-169,CHITWAN ESTATE,SECTOR - GAMMA,
GREATER NOIDA CITY - 201308
DISTT. GAUTAM BUDDH NAGAR (U.P.) INDIA

OWNER	ARCHITECT

SHEET TITLE:
LAYOUT PLAN
SHOWING WATER SUPPLY SYSTEM
(PHE DRAWING)

REV NO.	R-0	NORTH
DATE:	03.05.2016	
SCALE:	1:300@A1	
DEALT BY:	RAVI	
CHECK BY:	S.S. BHATIA	
DRG. NO.	DDA/GH-01A/1/ETA-II/SD-24	