


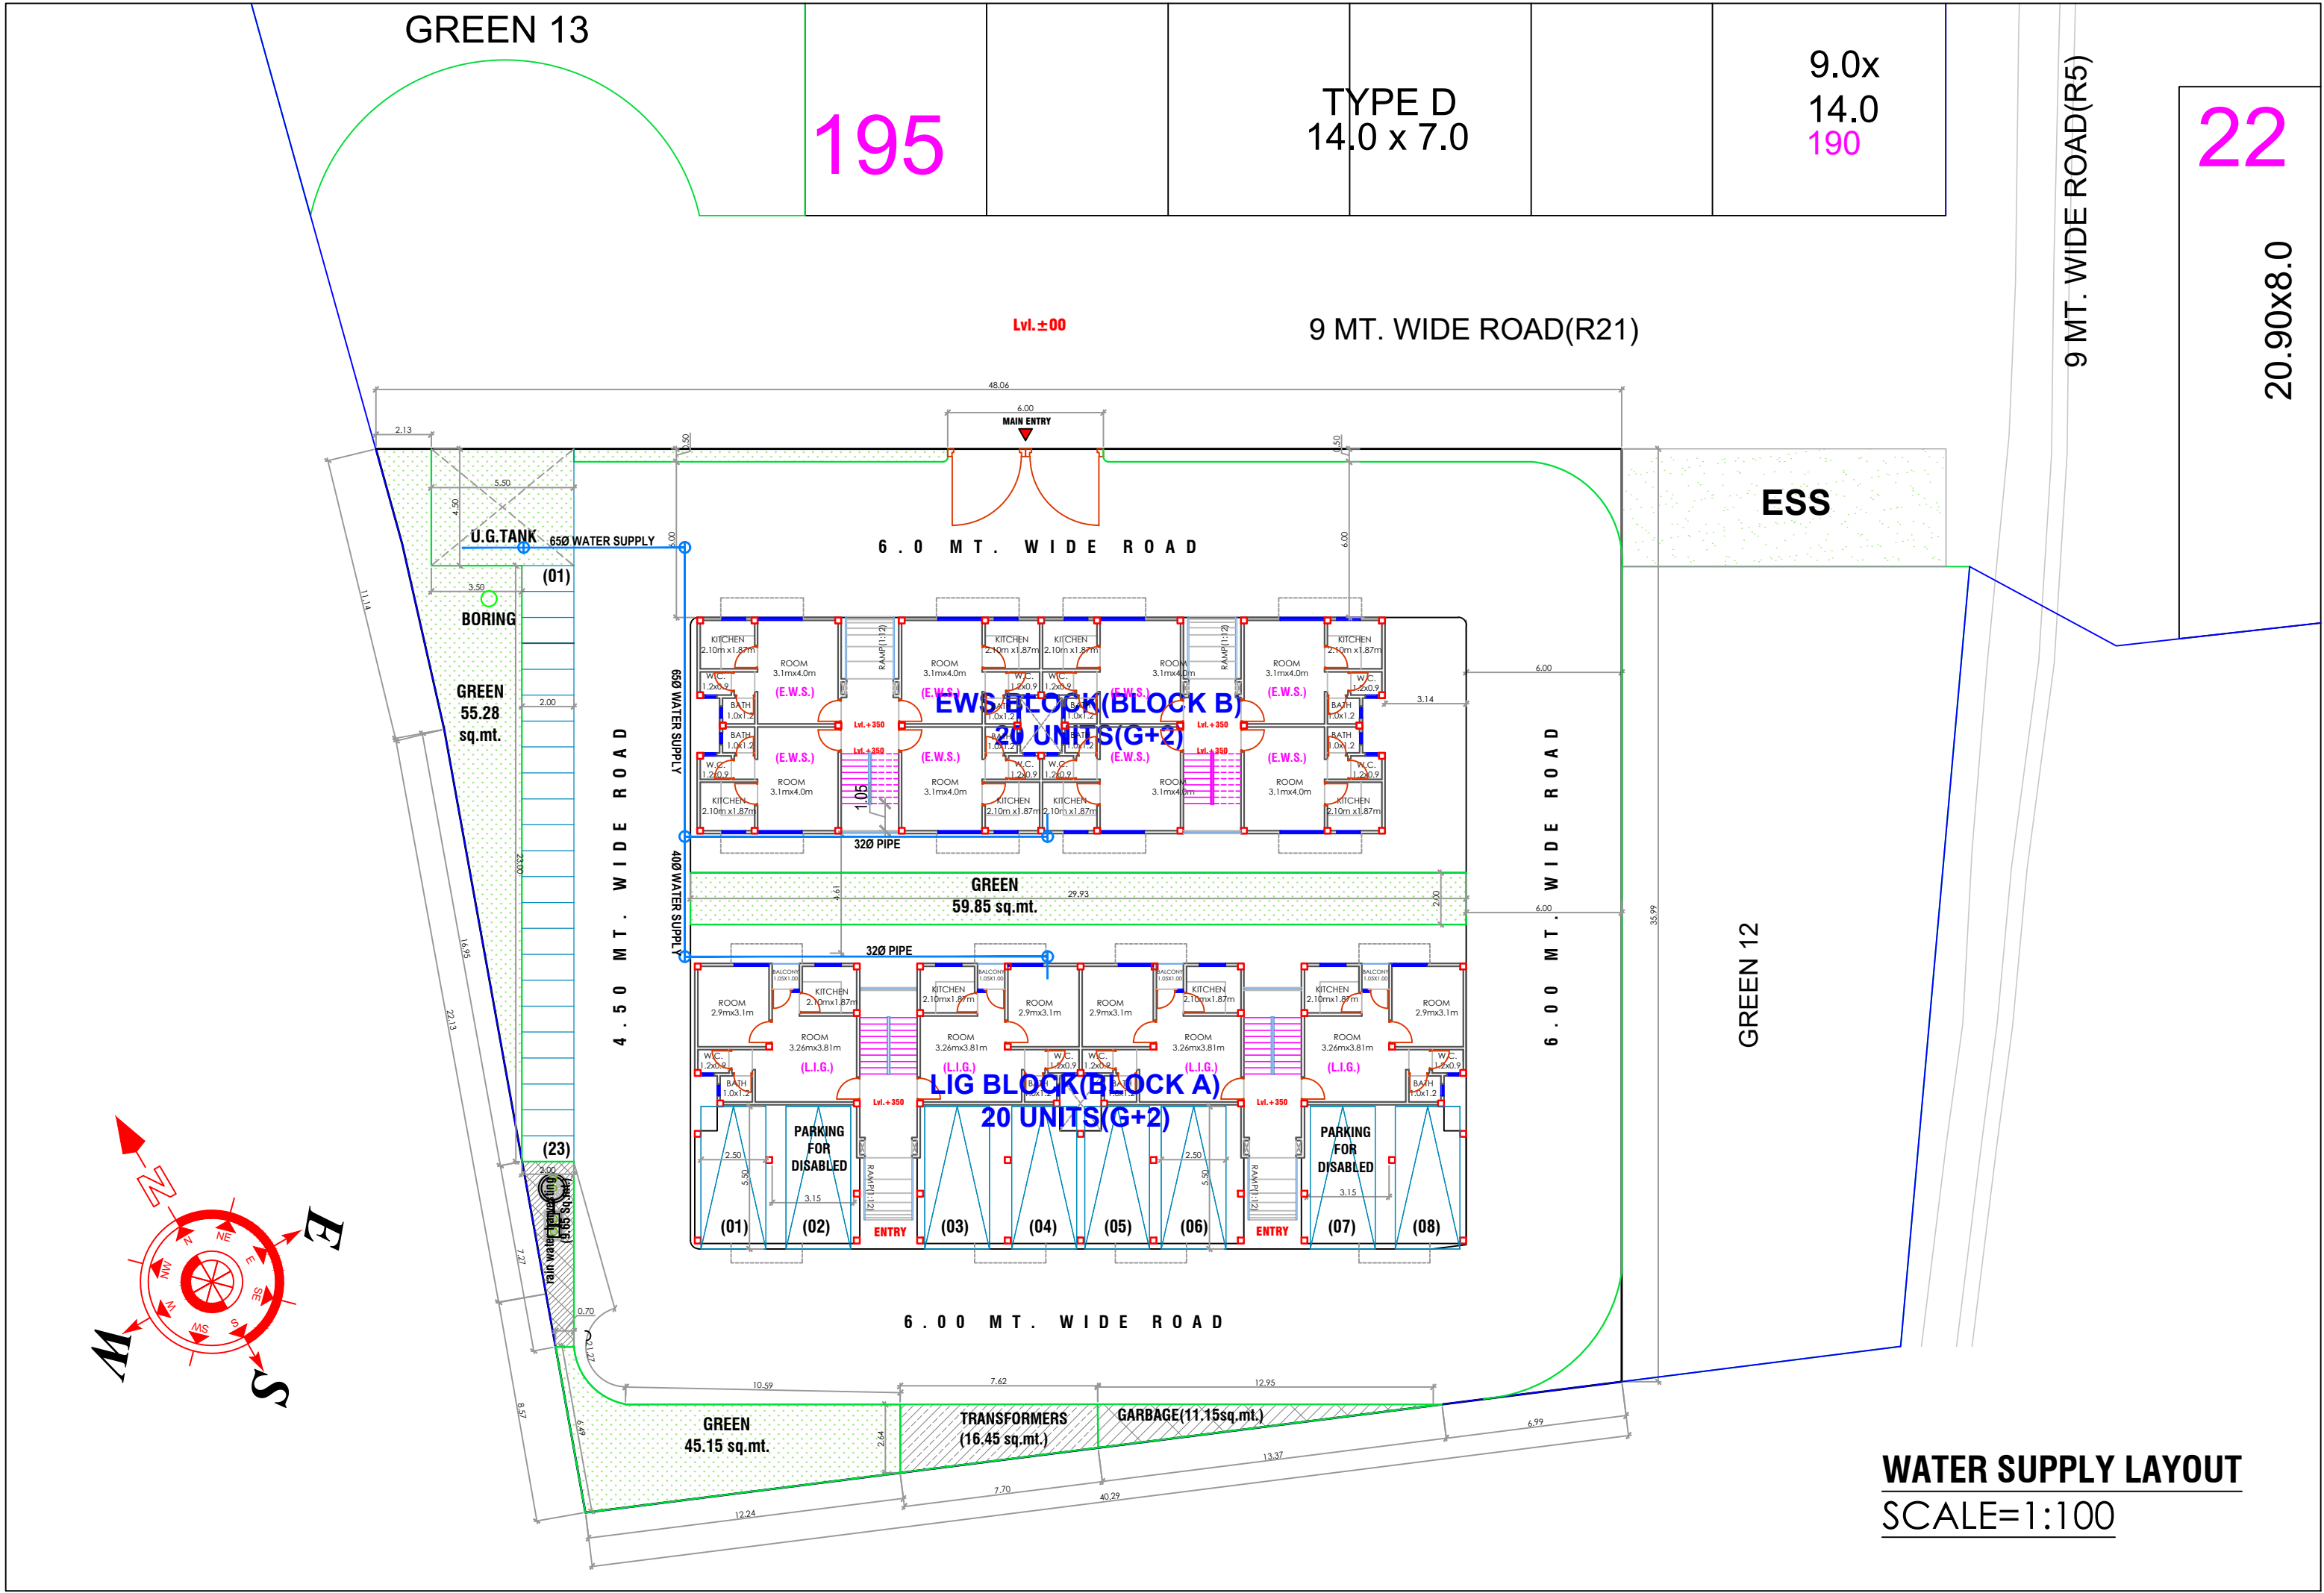

WATER SUPPLY LAYOUT
SCALE=1:100

WATER SUPPLY LAYOUT

PROPOSED HOUSING SCHEME AT
VILLAGE- JAITLEKHERA,
PARGANA-BIJNAUR, TEHSIL-SAROJINI
NAGAR, LUCKNOW INDUSTRIAL
DEVELOPMENT
AUTHORITY AREA, LUCKNOW

- NOTES:**
1. Architect shall not be responsible for any deviation at site by the developer.
 2. DEVELOPER SHALL ENSURE LEGAL POSSESSION OF PLOT BEFORE U.P.S.I.D.A. SUBMISSION.
 3. Layout approved vide permit no.2095, dated 16.03.2021.

PROMOTER:


Eldeco Housing & Industries Ltd.

DRG.NO.:
services/03

SCALE:
1:100


espaces
Ar.Sanjay Kumar Gupta
108/F. Floor, Corporate Chamber-1,
Vibhuti Khand Gomti Nagar,
Lucknow-226010
Ph.No.4065958,9415114589
email-espaces.arch@gmail.com

DEVELOPER:

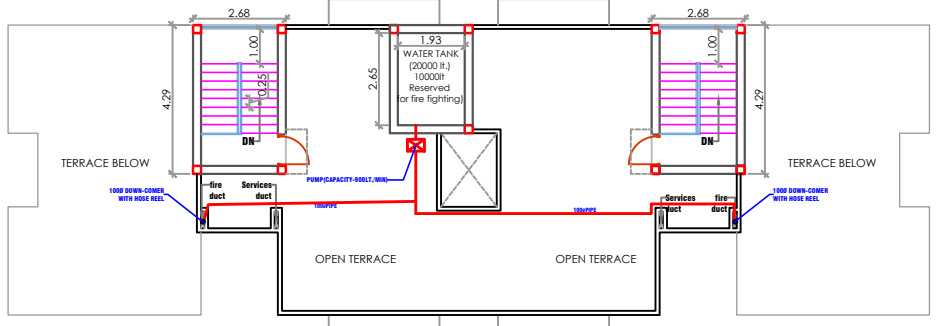

TERRACE FLOOR PLAN-EWS BLOCK (BLOCK B)
(SCALE 1:100)

NOT FOR CONSTRUCTION

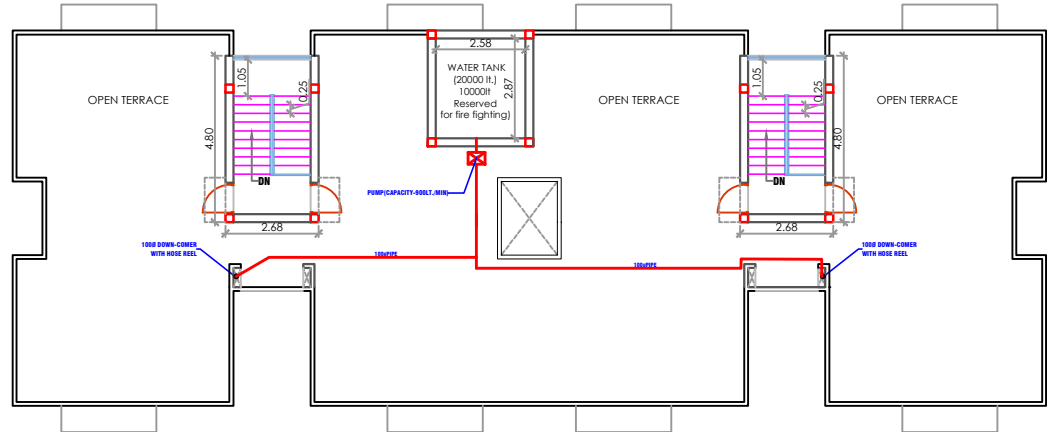

TERRACE FLOOR PLAN-LIG BLOCK (BLOCK A)
(SCALE 1:100)