


WATER SUPPLY PLAN

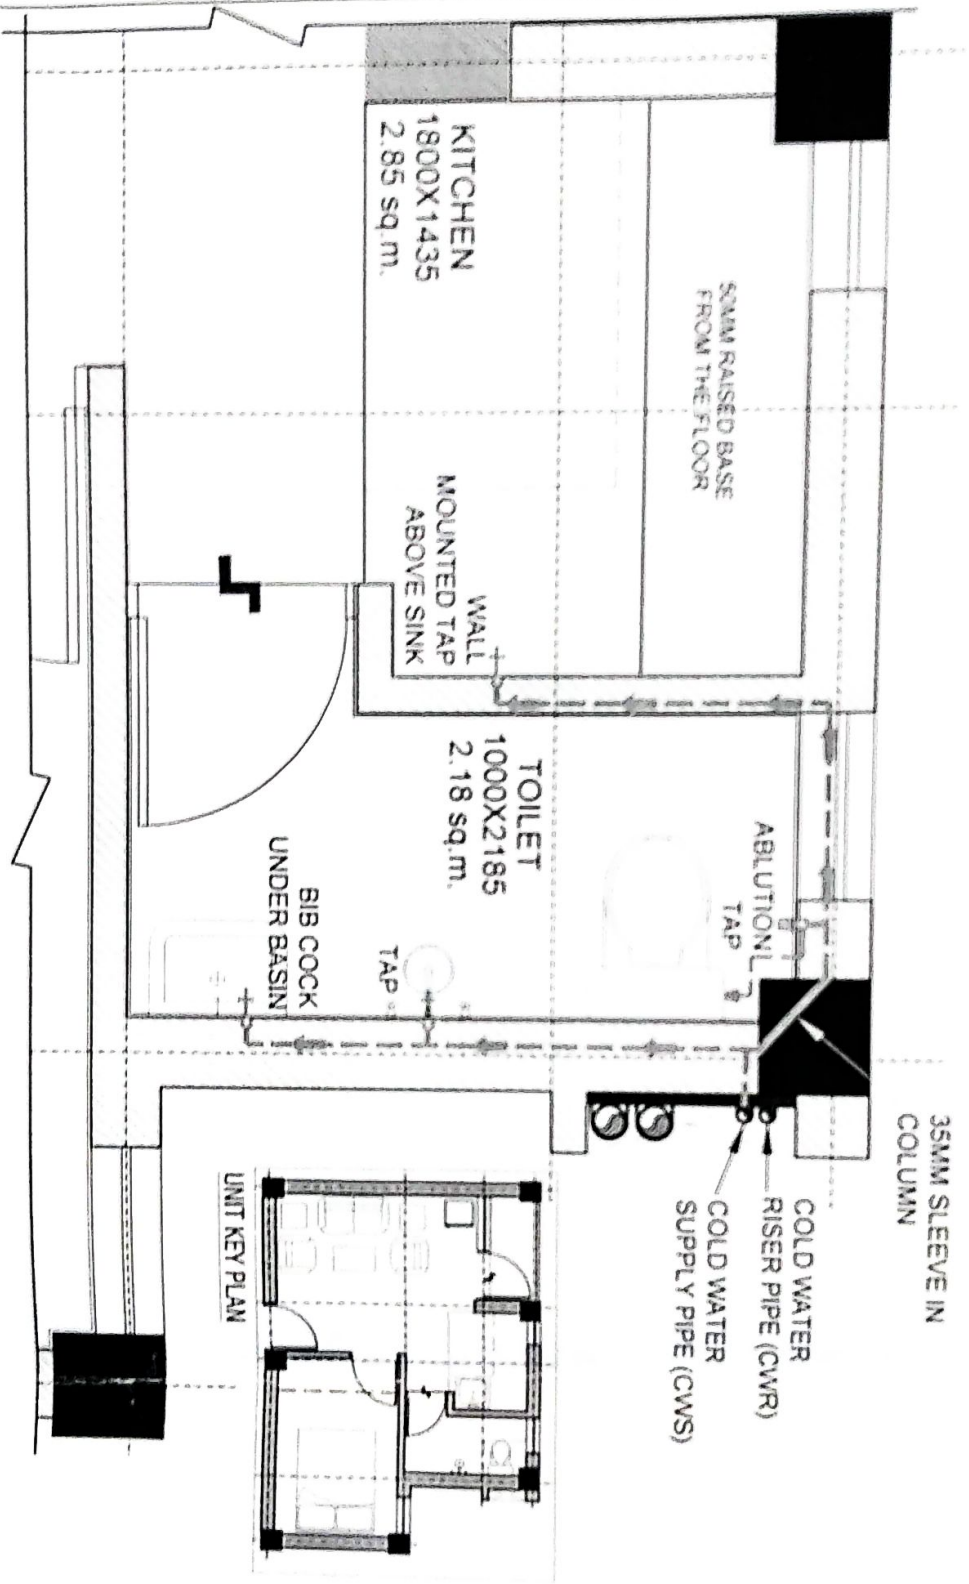

35MM SLEEVE IN COLUMN

COLD WATER RISER PIPE (CWR)
COLD WATER SUPPLY PIPE (CWS)

KITCHEN
1800X1435
2.85 sq.m.

TOILET
1000X2185
2.18 sq.m.

UNIT KEY PLAN

NOTE:

1. ALL WORKS TO BE DONE IN ACCORDANCE WITH THE SANS 10400 SERIES OF STANDARDS.
2. ALL MATERIALS TO BE USED SHALL BE OF THE BEST QUALITY AND SHALL BE SUPPLIED BY THE CONTRACTOR.
3. ALL WORKS TO BE DONE IN ACCORDANCE WITH THE SANS 10400 SERIES OF STANDARDS.
4. ALL WORKS TO BE DONE IN ACCORDANCE WITH THE SANS 10400 SERIES OF STANDARDS.
5. ALL WORKS TO BE DONE IN ACCORDANCE WITH THE SANS 10400 SERIES OF STANDARDS.

DOOR SCHEDULE

NO.	DESCRIPTION	QTY	UNIT	REMARKS
1	DOOR	1	EA	

DRAWING

REVISION

NO.	DATE	DESCRIPTION	INITIALS
1			

APPROVALS

INTERIMATED STUDIO FOR
EXPERIMENTAL ART LTD.
(PREF. INT. LTD.)

PROJECT TITLE

PMAY HEA2022 2500PHU
KURUOHUA VARAVASI

CLIENT

VARAVASI DEVELOPMENT AUTHORITY
VARAVASI

DRAWING TITLE

WATER SUPPLY PLAN

DRAWING CLERK

DESIGNED BY: DATE: 25-06-2020
SCALE: 1:20

CHECKED BY

APPROVED BY: 1:20