



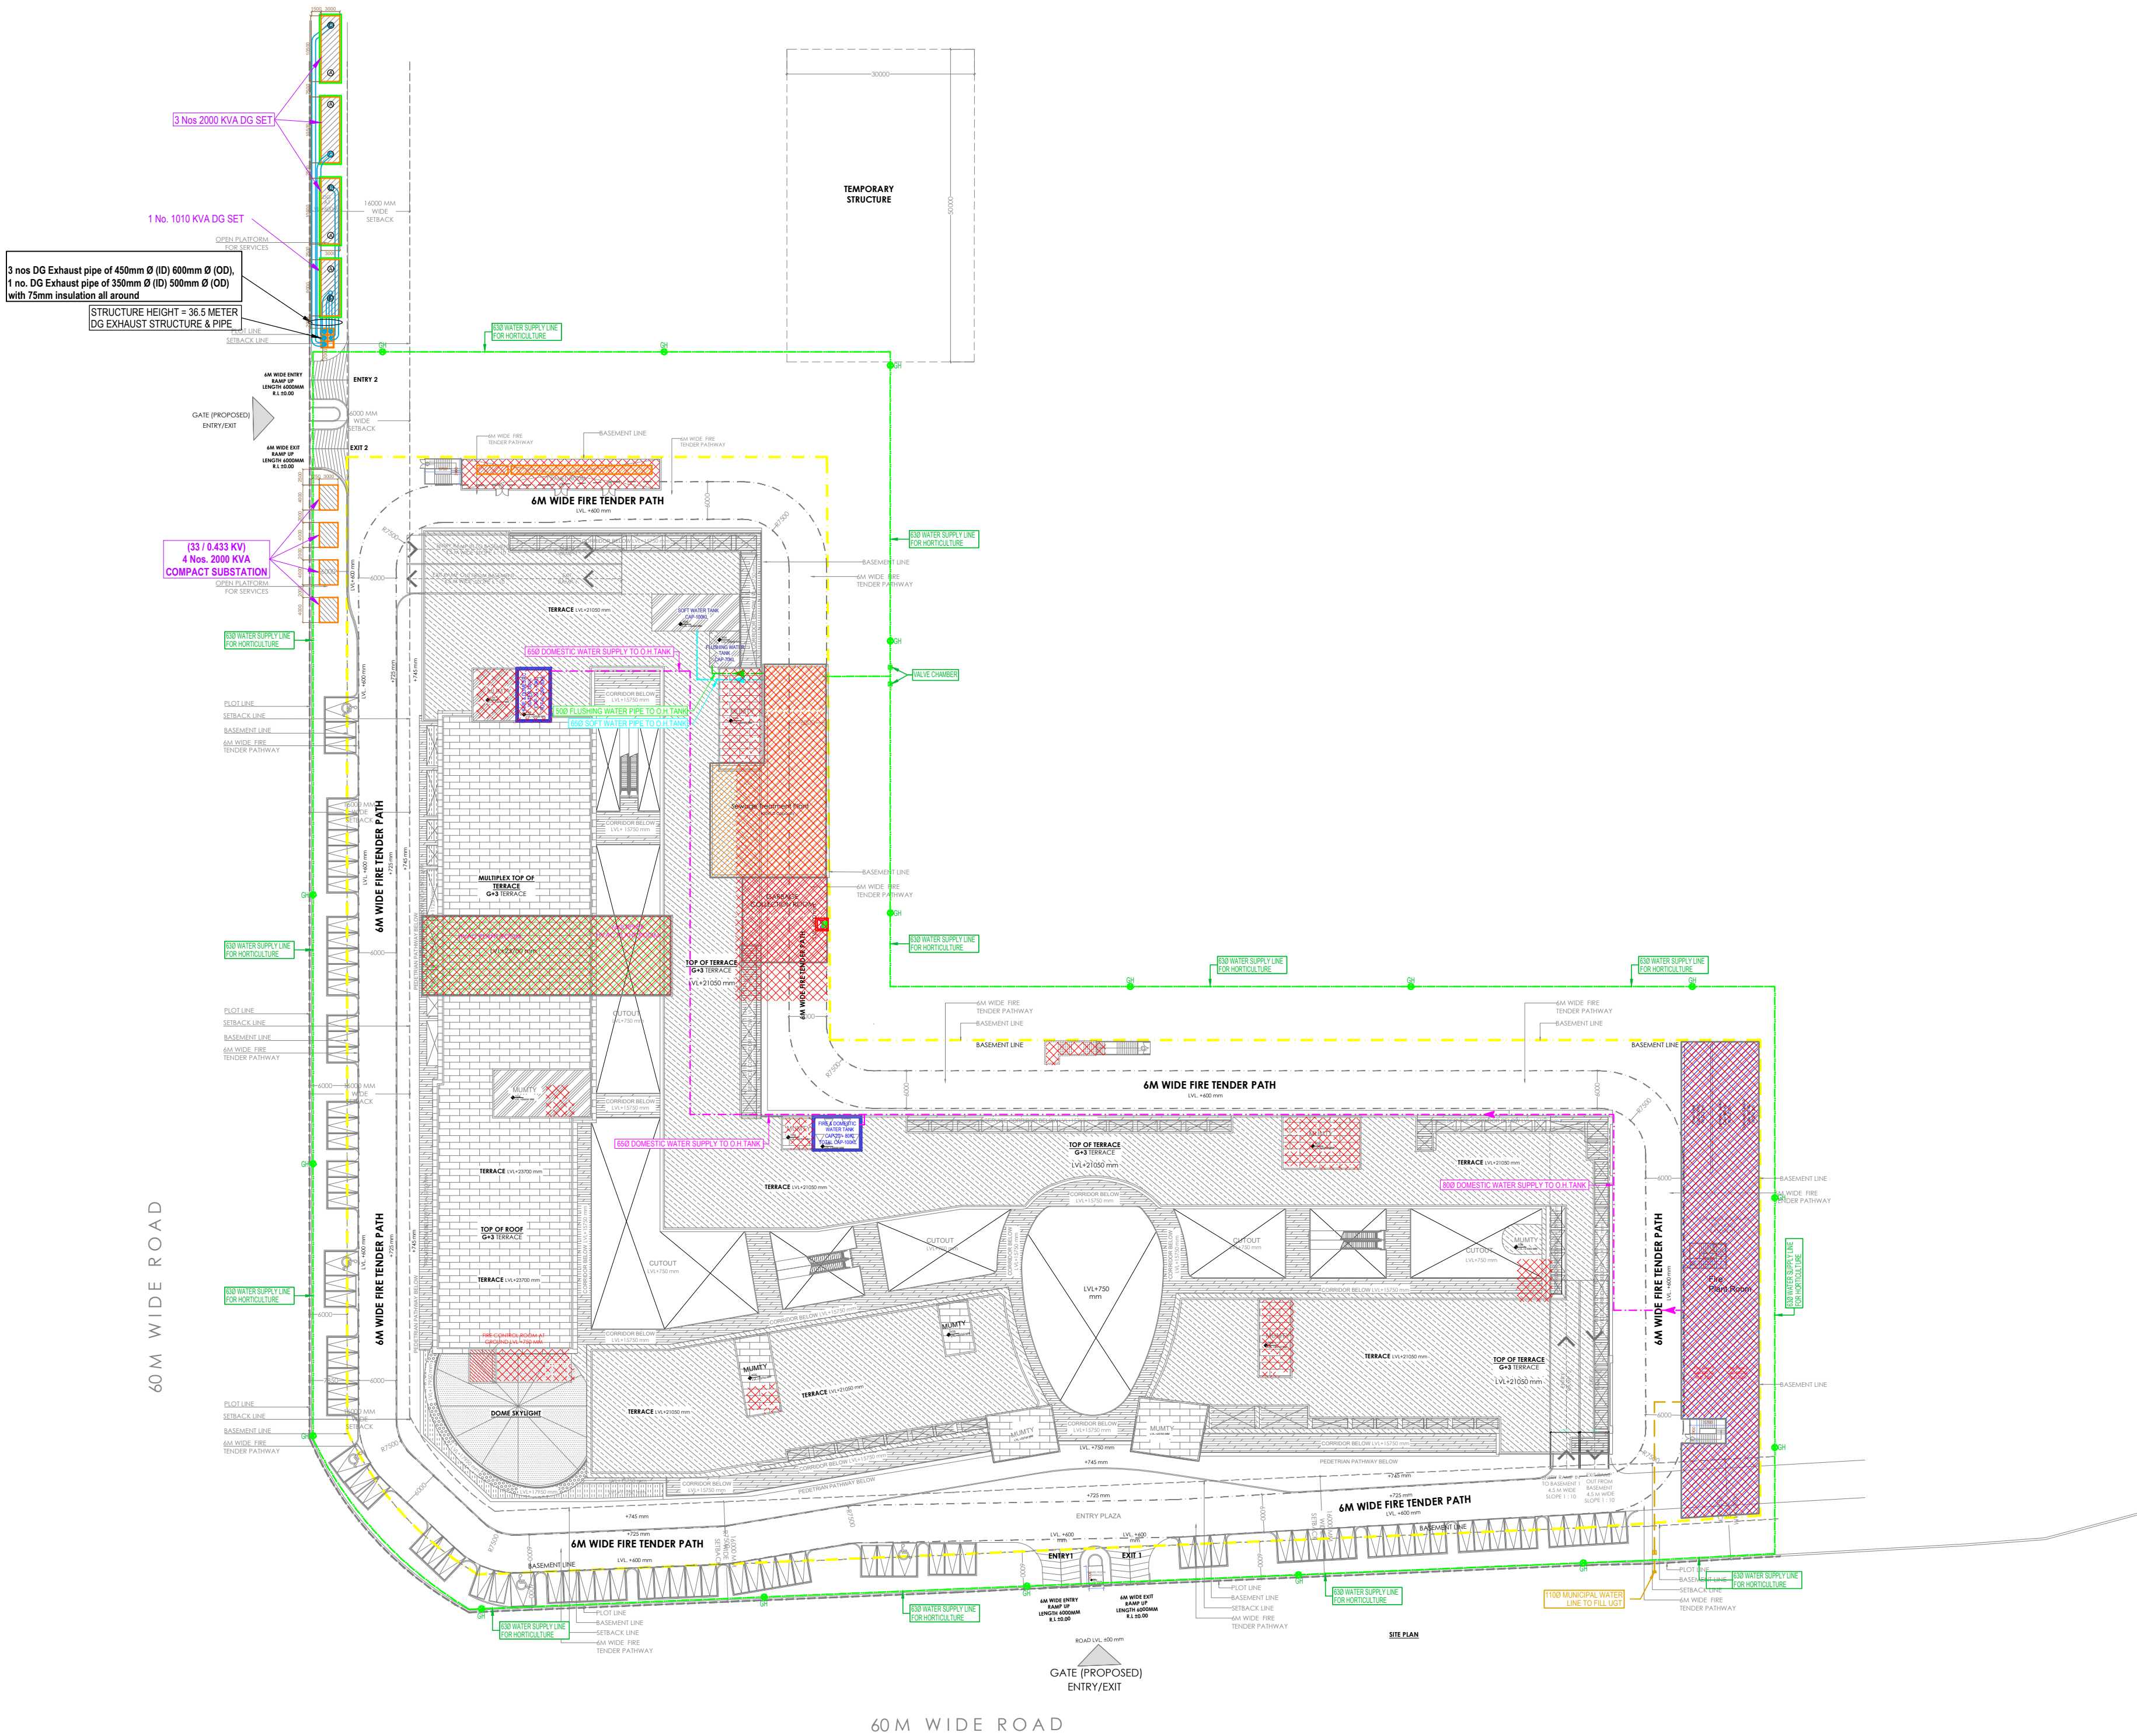

- NOTES:
1. ALL DIMENSIONS ARE IN MM.
 2. GATE AND BOUNDARY WALL SHALL BE AS PER STANDARD DESIGN.
 3. SPRINKLERS WILL BE PROVIDED IN ENTIRE BUILDING INCLUDING BASEMENTS AS PER N.B.C.
 4. RAIN WATER HARVESTING SYSTEM WILL BE PROVIDED AS PER APPLICABLE NORMS.
 5. 100% POWER BACK UP WILL BE PROVIDED FOR LIFTS & ESSENTIAL SERVICE AREAS.
 6. DISABLED RAMP @ 1:12 SLOPE WITH 900MM HIGH RAILING.
 7. ALL BUILDINGS ARE MECHANICALLY VENTILATED.
 8. BUILDING WILL BE DESIGNED (STRUCTURES) AS PER RELEVANT I.S. CODES FOR EARTHQUAKE RESISTANCE.

LEGEND :		
S. No.	SYMBOL	DESCRIPTION
1.		DOMESTIC WATER SUPPLY PIPE (DWS)
2.		FLUSHING WATER SUPPLY PIPE (FWS)
3.		FLUSHING WATER SUPPLY PIPE (SWS)
4.		IRRIGATION WATER SUPPLY PIPE (IWS)
5.		MUNICIPAL WATER SUPPLY PIPE LINE
6.		MASONRY CHAMBER FOR ISOLATING VALVE
7.		MASONRY CHAMBER FOR ISOLATING VALVE
8.		GARDEN HYDRANT

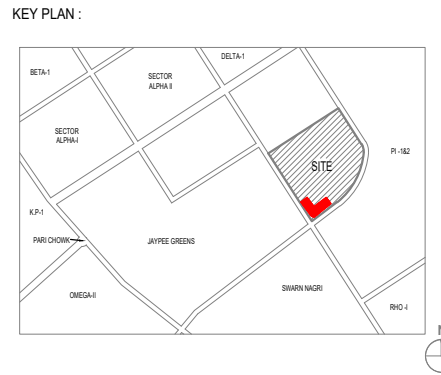

services consultant
Cespi Consultants Pvt. Ltd.
B-47, Sector-47, Noida-201301
Tel : (0120) 3225400 / 3225401
e mail : mail@cespi.in, website : www.cespi.in

**SUBMISSION DRAWING
EXTERNAL WATER SUPPLY LAYOUT**

OWNER :
M/S A R LANDCRAFT LLP.

PROJECT :
**PROPOSED BUILDING PLAN OF
RECREATIONAL ENTERTAINMENT PARK
AT PLOT NO. REP.1 SECTOR - 27
GREATER NOIDA (U.P.) ,
BELONGING TO M/S A R LANDCRAFT
LLP.**

ARCHITECTS :
Golden India Architects
F.F - 37, KADAMBA SHOPPING COMPLEX ,
GAMMA - 1, GREATER NOIDA - 201310

DESIGN BY :
ACPL
ACPL Design Ltd
B-24 South Extension -1
New Delhi 110048, India
P : +91 11 4824444
M : +91 9810000000
E : acpl@acpl.in, www.acpl.in

DRAWING TITLE :
SITE PLAN

SCALE :
1:500

NORTH :

DRAWING NO :
PL-03