



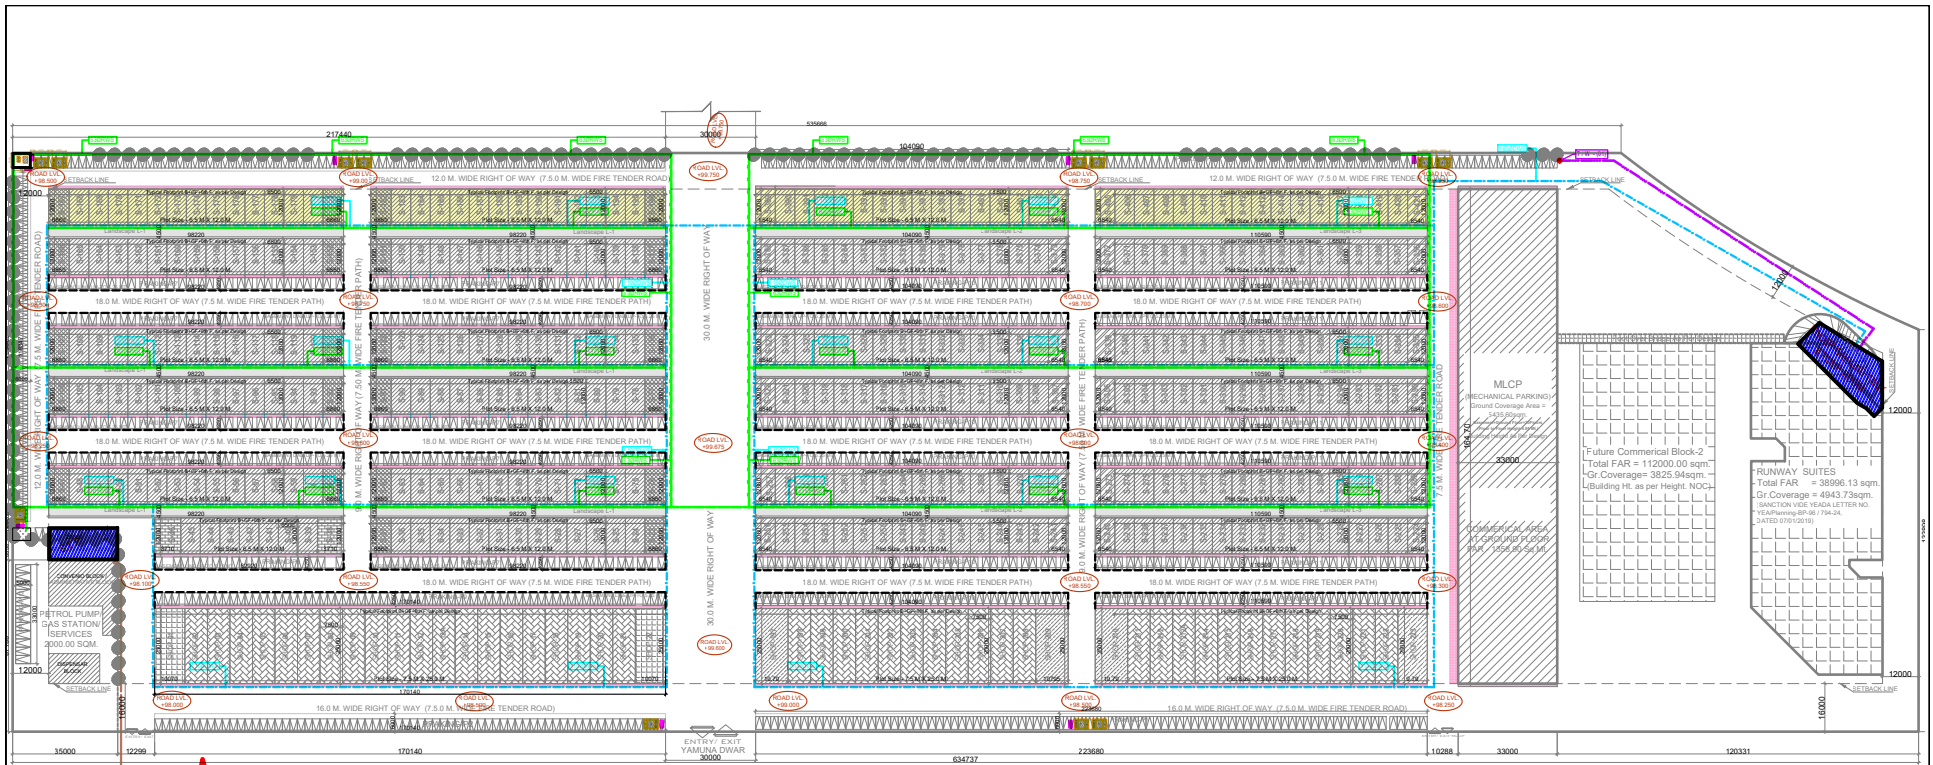

NOTE: ALL DIMENSION OF THE LAYOUT PLAN ARE IN M.

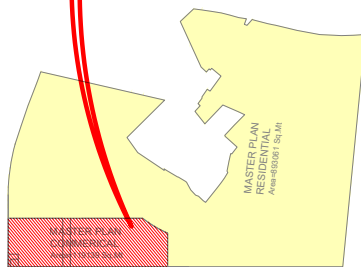

KEY PLAN, GAUR YAMUNA CITY
(Pocket-3), Mirzapur Site
(LFD-3), Sector-19, YEIDA, GREATER NOIDA, U.P.

S. No.	SYMBOL	DESCRIPTION
1.		SEWERAGE WATER SUPPLY PIPE (SWSP)
2.		DRINKING WATER LINE (DWL) (FROM TWP TO U.S.T.)
3.		PROPOSED TUBE WELL
4.		MUNICIPAL WATER SUPPLY PIPE LINE
5.		MASONRY CHAMBER FOR ISOLATING VALVE
6.		YARD HYDRANT
7.		RECYCLED WATER SUPPLY LINE (RWSL) (FROM TWP TO U.S.T.)
8.		GARDEN HYDRANT

Drg. No. - MPC-03

PROJECT : -
PROPOSED BUILDING FOOT PRINTS AT
MASTER PLAN COMMERCIAL, GAUR YAMUNA
CITY (POCKET-3), MIRZAPUR SITE (LFD-3),
SECTOR-19, YEIDA, GREATER NOIDA, U.P.

Title :

SITE PLAN

Subtitle :

EXTERNAL CO-ORDINATED LAYOUT

Drawing Released For :

- ☐ APPROVAL
- ☐ ADVANCE COPY
- ☒ SUBMISSION
- ☐ CONSTRUCTION

Drg. No. :

GYC / MC / SP - 03

Date :

23.07.2020

Scale :

A1@1:800

Drawn By :

S.Bhandari

Design By :

Shakir Shabbir

Ckd By :

Anand Havelia

architects

BRJ (INDIA) ARCHITECTS
F-89, GREEN PARK, NEW DELHI -16.
Ph. +91-11-26853815, 26858307, Fax : +91-11-26850788
E-mail : biarch.atwin@gmail.com
Website: www.atwin.in

services consultant

Consummate Engineering Services (P) Ltd.

Noida Office : B - 67, Sector - 67, Noida - 201 301
Tel : (0120) 26843500 (24 Lines)
Lko. Office : R 006, Rohtas Plumeria, Gomti Nagar, Lucknow
e mail : mail@cespl.in, website : www.cespl.in