


LEGEND		
SR.NO	SYMBOL	DESCRIPTION
01.		50W LED STREET LIGHT ON 4.5 METER POLE
02.		63mmOD HDPE PIPE FOR LT CABLE TO PLOT
03.		300mm DIA PVC PIPE FOR LT CABLE
04.		600X600 CABLE TRENCH FOR LT CABLE
05.		300MM DIA RCC HUME PIPE FOR HT CABLE
06.		100mm DIA PIPE FOR FIBER CABLE
07.		FIBER JB BY SERVICE PROVIDER
08.		300X300 MANHOLE FOR LV SYSTEM
09.		750X750 MANHOLE FOR ELECTRICAL
10.		63mm OD HDPE PIPE FOR STREET LIGHT

LEGEND:-	
SYM.	DESCRIPTION
	LT. ELECTRICAL LINE
	ELEC. PIT(600 X 600)
	LT. ELECTRICAL LINE
	EXTERNAL LIGHTING PANEL
	STREET POLE LIGHT

PROJECT: SUBMISSION DRAWING FOR PROPOSED CONVINIENT SHOP - C2 RESIDENTIAL LAYOUT AT KHASRA NO. - 1228m , 1229 , 1218m & 1219m VILLAGE NOOR NAGAR GHAZIABAD (U.P.)	
OWNER: M/s. - ASM MANAGMENT CONSULTANTS PVT. LTD.	
AUTH. SIGN. - GAJENDRA PAL SHARMA	
DRAWING TITLE: CONVINIENT SHOP - C2 (EXTERNAL ELECTRICAL PLAN)	
OWNER'S SIGN	ARCHITECT'S SIGN.
 ANUJ AGARWAL ARCHITECTS OFFICE:- A-244 KAUSHAMBI GHAZIABAD (U.P.) Ph:-0120 - 4165716 , 4563716 , 6454182 e-mail : arch.anujagarwal@gmail.com	
SCALE	DEALT BY A. CHAUHAN
DESIGN BY	CHECKED BY
DATE	
DRG. No.	
SD-01	

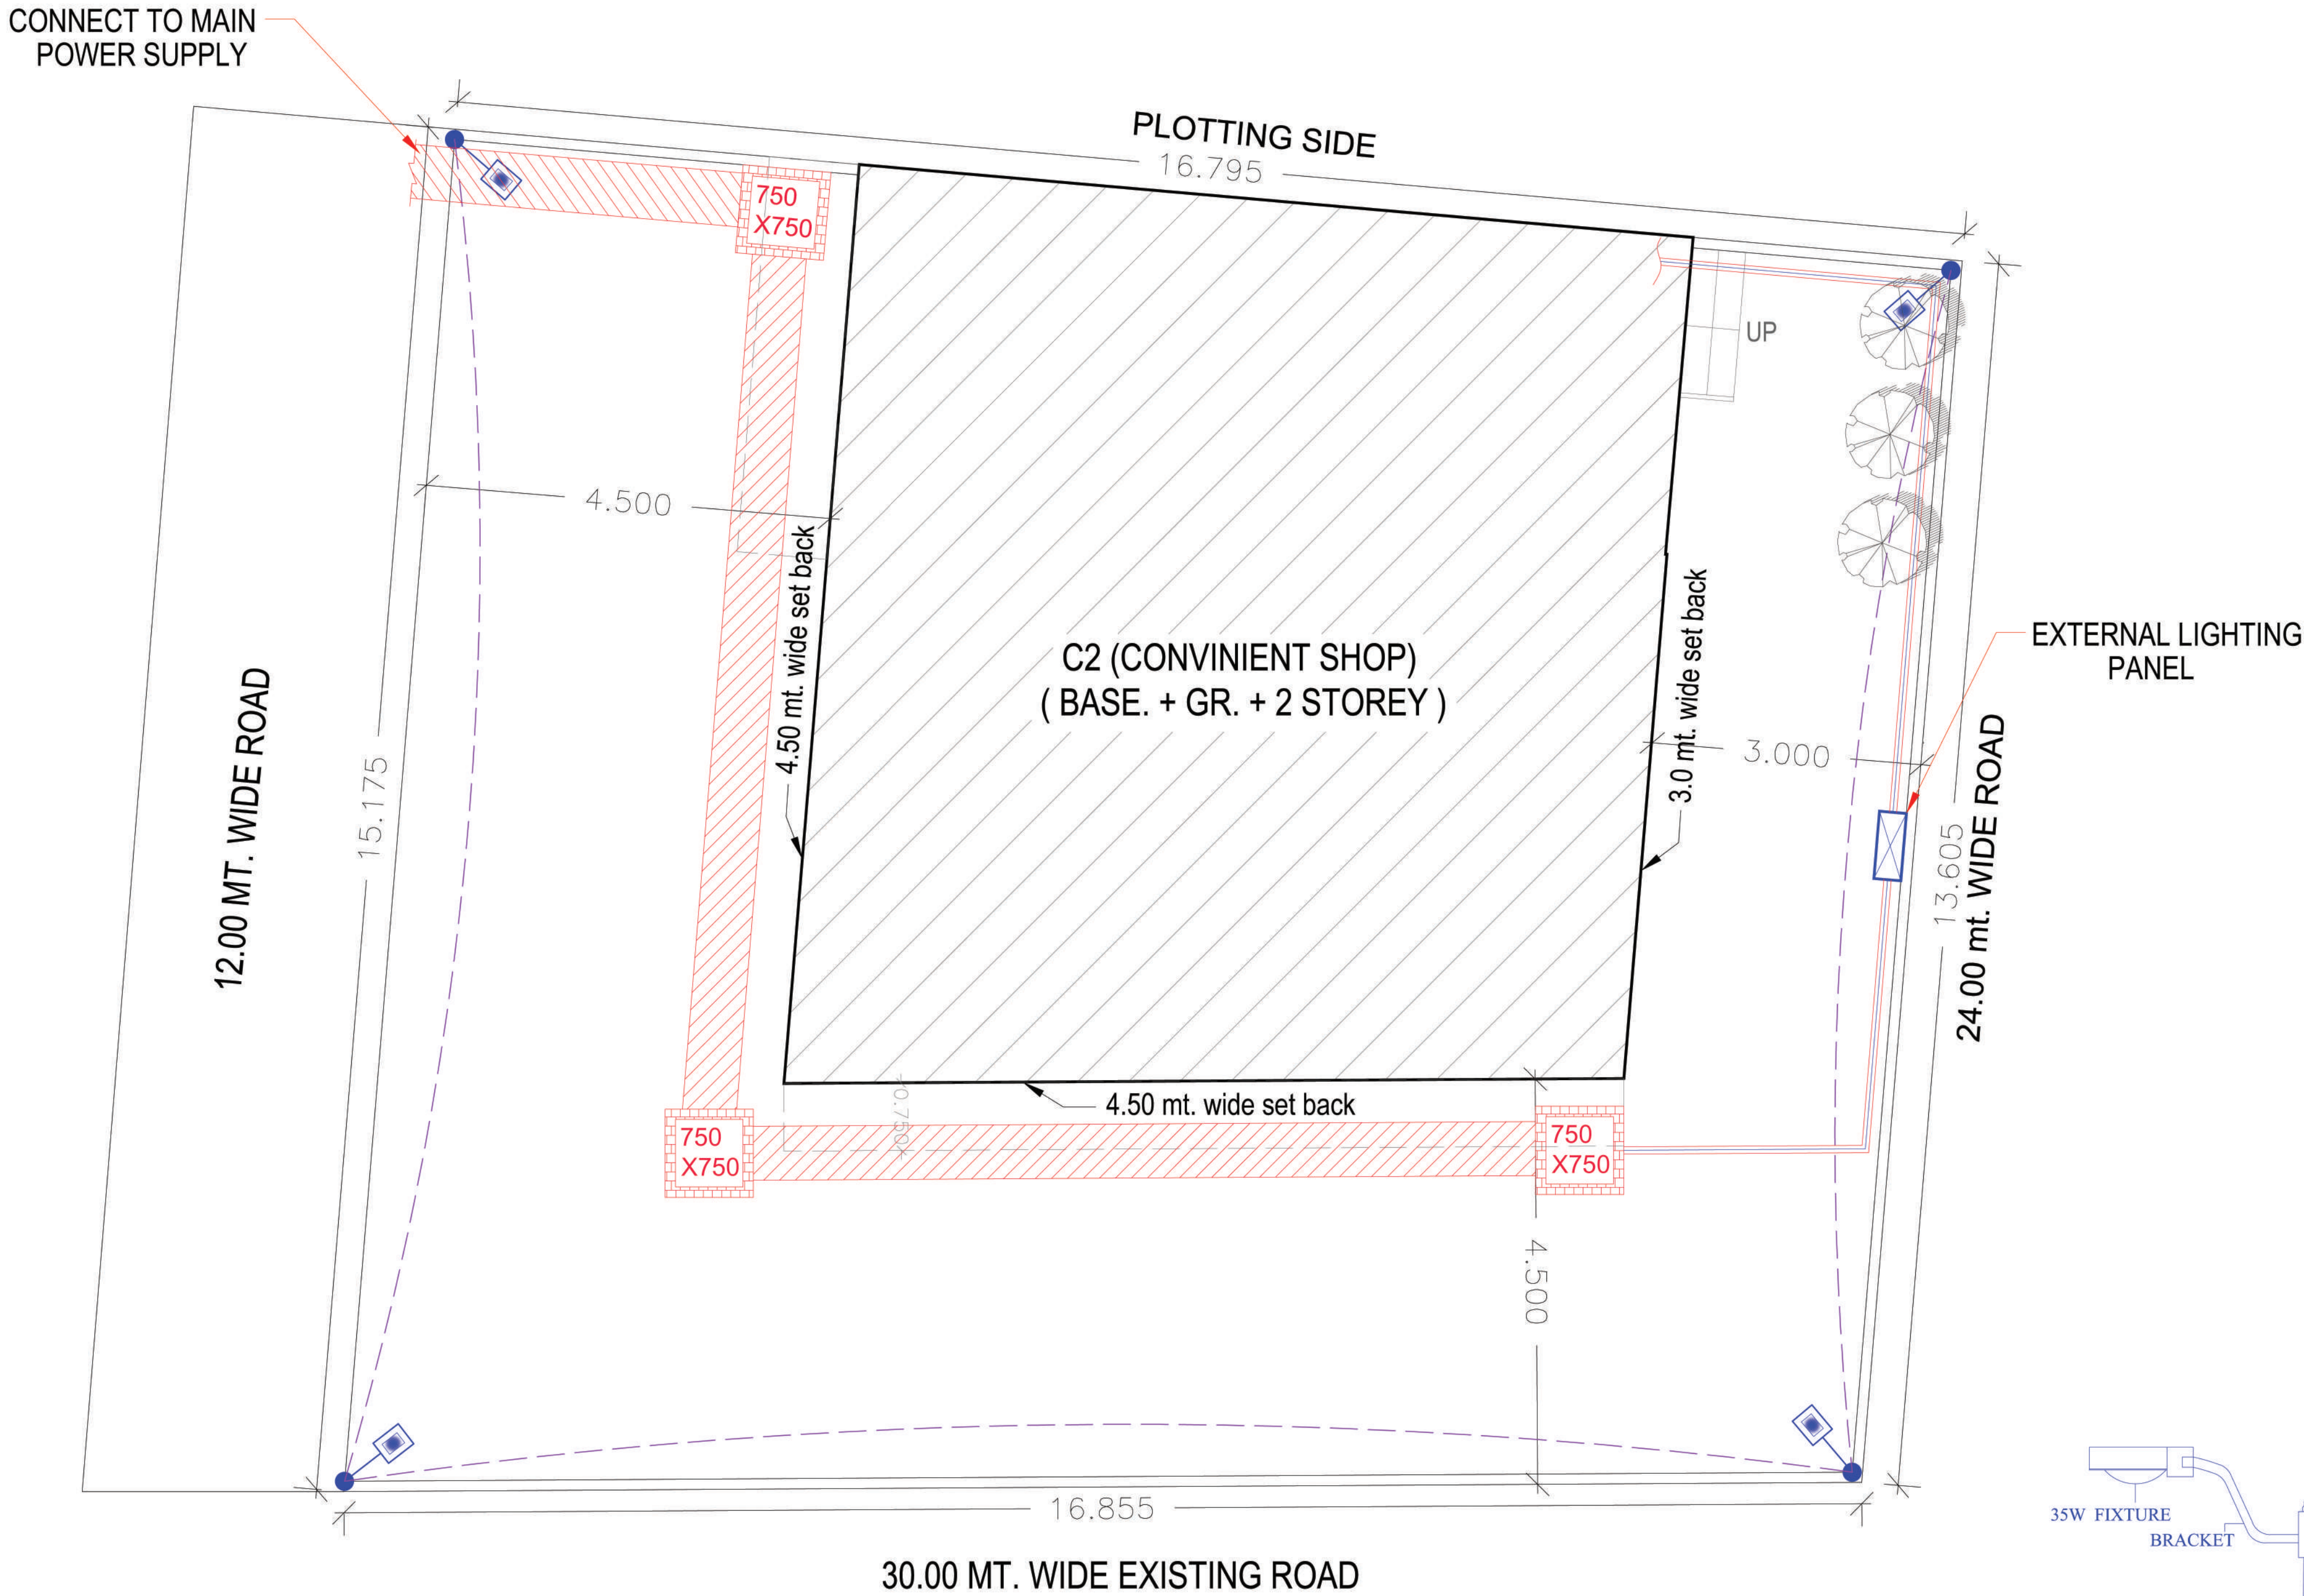

EXTERNAL ELECTRICAL PLAN

