




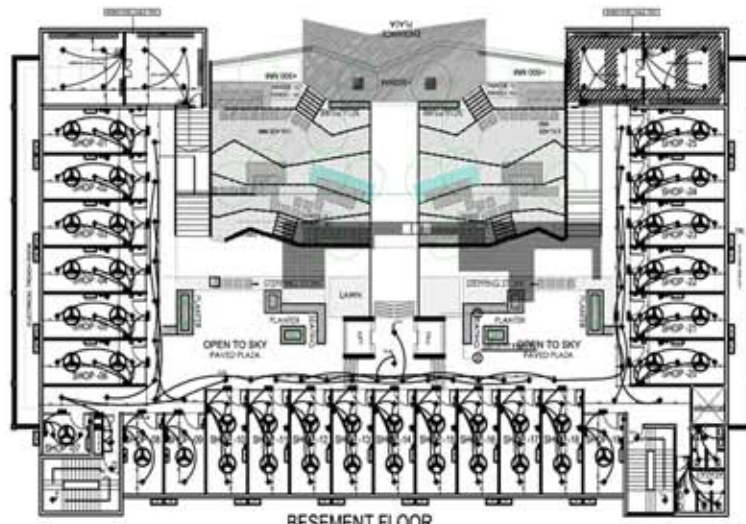


BESEMENT FLOOR

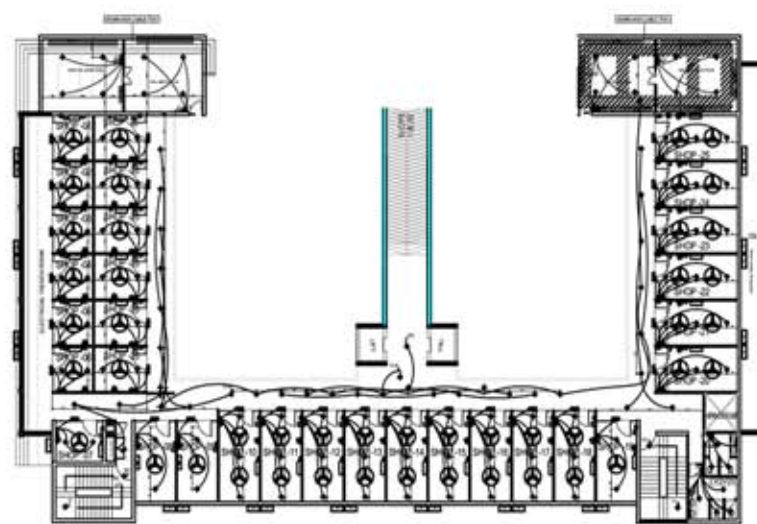


FIRST FLOOR

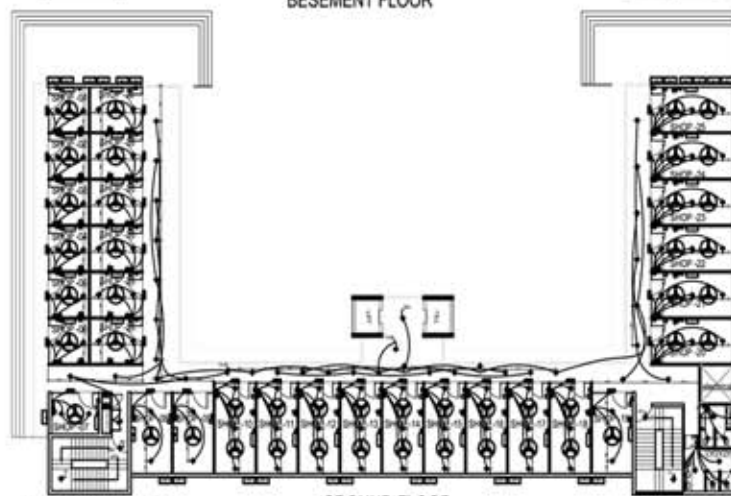

GROUND FLOOR

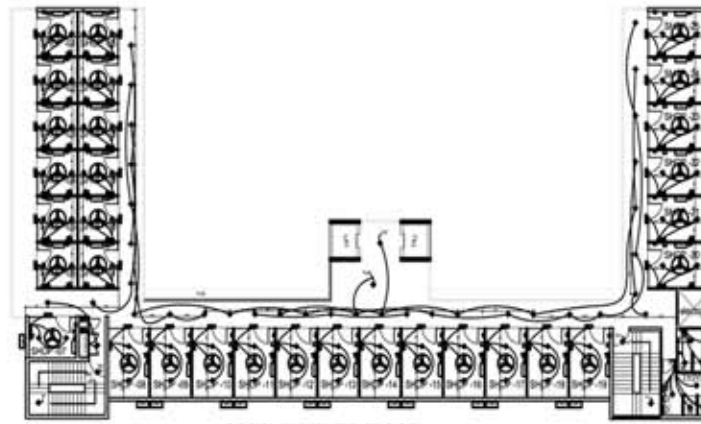

SECOND & THIRD FLOOR

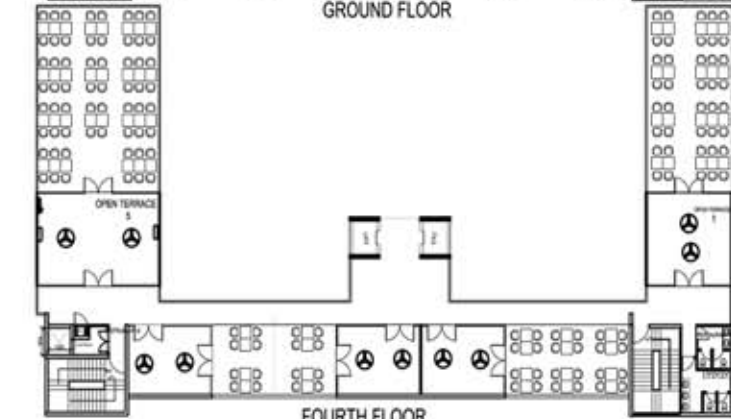

FOURTH FLOOR

S. No.	SYMBOL	DESCRIPTION	POSITION
1.		CEILING LIGHT (SURFACE)	
2.		EMERGENCY CEILING LIGHT (SURFACE)	
3.		MIRROR LIGHT	200
4.		EXHAUST FAN CEILING ROSE	200
5.		ENTRANCE FOR DOUBLE BEAM LIGHT	
6.		LIGHT POINT WALL BRACKET	200
7.		CEILING FAN	
8.		T.V. ANTENNA POINT	100
9.		TELEPHONE	100
10.		4 AMP SWITCH SOCKET (FOR T.V.)	100
11.		4 AMP SWITCH SOCKET	100
12.		20 AMP DP SWITCH (FOR A.C.) WITH 10 AMP SWITCH SOCKET	100
13.		T.V. JUNCTION BOX	200
14.		DISTRIBUTION BOARD (TOP LEVEL)	200
15.		REGULATED CONTROL PANEL OF LIGHTING FROM CENTRAL PLANT	
16.		1000W AC UNIT	
17.		2000W AC UNIT	
18.		NEGATIVE CONDUIT RUN FOR ALARM UNIT	
19.		NEGATIVE CONDUIT RUN FOR LIGHTING UNIT	
20.		NEGATIVE CONDUIT RUN FOR POWER UNIT	
21.		SMOKE DETECTOR	
22.		REFERENCE NAVIGATION	
23.		NEGATIVE CONDUIT RUN FOR ALARM UNIT (1 TO 1000W AC UNIT)	
24.		MANUAL GLASS POINT (BREAK GLASS TYPE)	100
25.		T.V. BRACKET UNIT	100
26.		ELECTRONIC NOTIFIER - SPEAKER	200
27.		NEGATIVE CONDUIT RUN FOR FIRE ALARM SYSTEM	
28.		20mm Ø ELECTRICAL SLEEVE	
29.		25mm Ø Ø ELECTRICAL SLEEVE	

NO.	02-10-2019	ISSUED FOR CONSTRUCTION
REV. NO.	DATE	REVISION

PROJECT
RISE RESORT RESIDENCE (RISE RETAIL)
COMMERCIAL

TITLE
ELECTRICAL WIRING DRAWING

SUBTITLE
LIGHTING LAYOUT
RISE RETAIL

DRAWING RELEASED FOR
☐ APPROVAL ☐ SUBMISSION
☐ ADVANCE COPY ☒ CONSTRUCTION

DWG. NO. 888 / COM / EL / 01

SCALE 1:1250 (A1)

DATE Feb. 2019

DRAWN BY M. Zaidi

DESIGNED BY M. Waseem

CHECKED BY Anand Havelli

ARCHITECTS
VAIBHAV JAIN & ASSOCIATES
R-10, 10th Floor, Sector-17, Gurgaon, Haryana
Gurgaon, Haryana, India. Phone: 91-124-4511111, 4511112, 4511113, 4511114, 4512186, 4