


PROPOSED DEVELOPMENT FOR PLOT
MEASURING 24.716 ACRES IN SECTOR
TECH ZONE - 4, PLOT NO.-17
GREATER NOIDA,
BEING DEVELOPED BY M/S S.P. SAI IT
Pvt. Ltd.

KEY PLAN

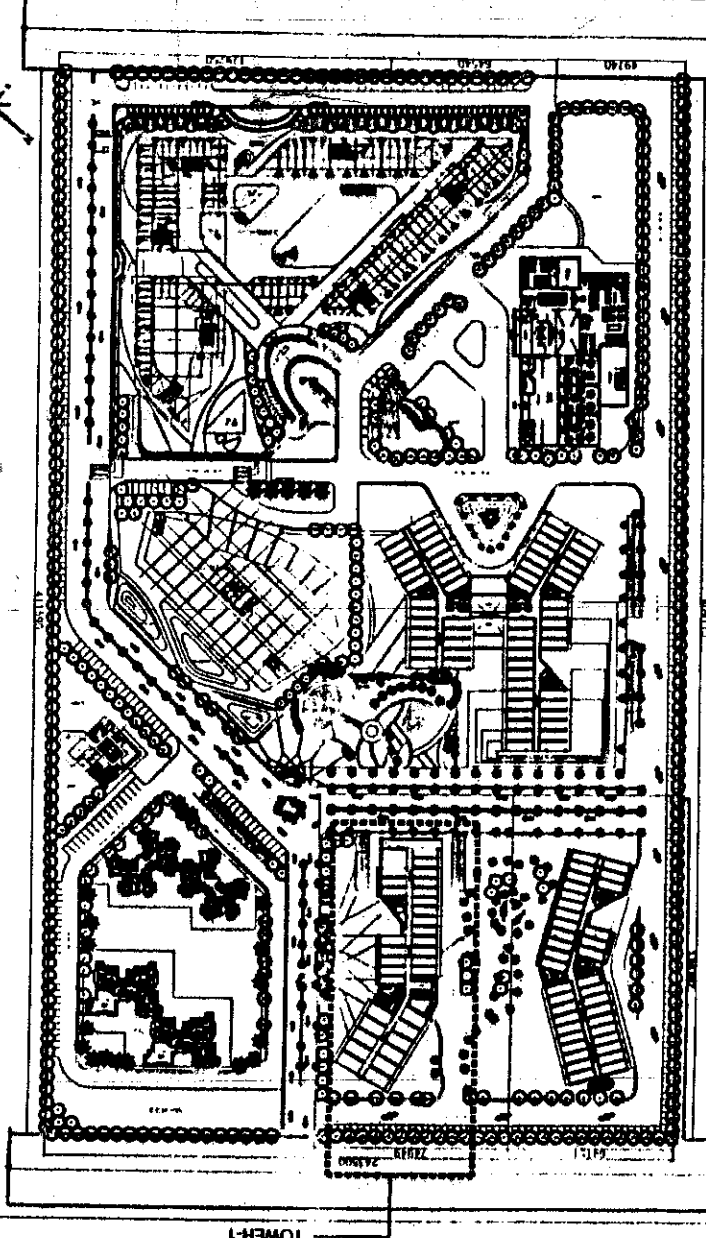


TOWER - 1

SR. NO.	TYPE	WIDTH	LENGTH	AREA	PERIMETER
1	D1	1000	2400	2400	1000
2	D2	990	2400	2400	1000
3	D3	750	2400	2400	1000
4	D4	1200	2400	2400	1000
5	D5	1790	2400	2400	1000
6	FD	1200	2400	2400	1000
7	DW1	4825	3250	3250	1000
8	DW2	5310	3250	3250	1000
9	DW3	3465	3250	3250	1000
10	DW4	3465	3250	3250	1000
11	DW5	2415	3250	3250	1000
12	DW6	3280	3250	3250	1000
13	DW7	4940	3250	3250	1000
14	V1	1000	2400	2400	1000
15	V2	840	2400	2400	1000

PLUMBING LEGENDS

1 - 100 MM DIA SOIL WASTE PIPE
2 - 100 MM DIA WASTE PIPE
3 - 75 MM DIA ASP
4 - 65 MM DIA UP PIPE
5 - 65 MM DIA DOWN PIPE
6 - 150 MM DIA RAIN WATER PIPE

11TH FLOOR AREA CHART		DEDUCTIONS		X Y = 38.850 X 99.795 = 3877.0357	
SR.NO.	AREA (SQ.MT.)	SR.NO.	AREA (SQ.MT.)	SR.NO.	AREA (SQ.MT.)
A	19.605	12	332.844	S	22.225
B	19.245	11	106.906	R	9.826
C	16.625	10	239.317	Q	27.475
D	16.625	9	995.754	P	2.020
E	1.952	8	10.375	O	2.540
F	1.952	7	0.521	N	2.540
G	1.952	6	0.504	M	8.445
H	1.956	5	20.968	L	8.445
I	1.207	4	0.223	K	3.698
J	4.240	3	3.18	J	4.240
K	3.698	2	2.774	I	1.207
L	8.445	1	39.599	H	1.956
M	8.445	1	43.699	G	1.956
N	2.540	1	3.951	F	1.952
O	2.540	1	0.246	E	1.952
P	2.020	1	0.374	D	16.625
Q	27.475	1	610.495	C	16.625
R	9.826	1	76.220	B	19.245
S	22.225	1	428.498	A	19.605
TOTAL DEDUCTION Z		TOTAL FLOOR AREA = (X*Y) - Z		TOTAL SERVICE AREA (A)	
	2916.447		(3877.0357 - 2916.447) = 960.588 SQ.MT.	1	4.470
				2	7.290
				3	5.417
				4	1.738
				5	8.132
				6	3.127
				7	0.490
				8	6.505
				9	4.443
				10	4.443
				11	3.843
				12	0.600
				13	4.032
				14	1.260
				15	2.580
				16	0.186
				17	0.548
				18	2.305
				19	0.600
				20	1.900
				21	1.900
				22	1.900
				23	1.900
				24	1.900
				25	1.900
					164.403

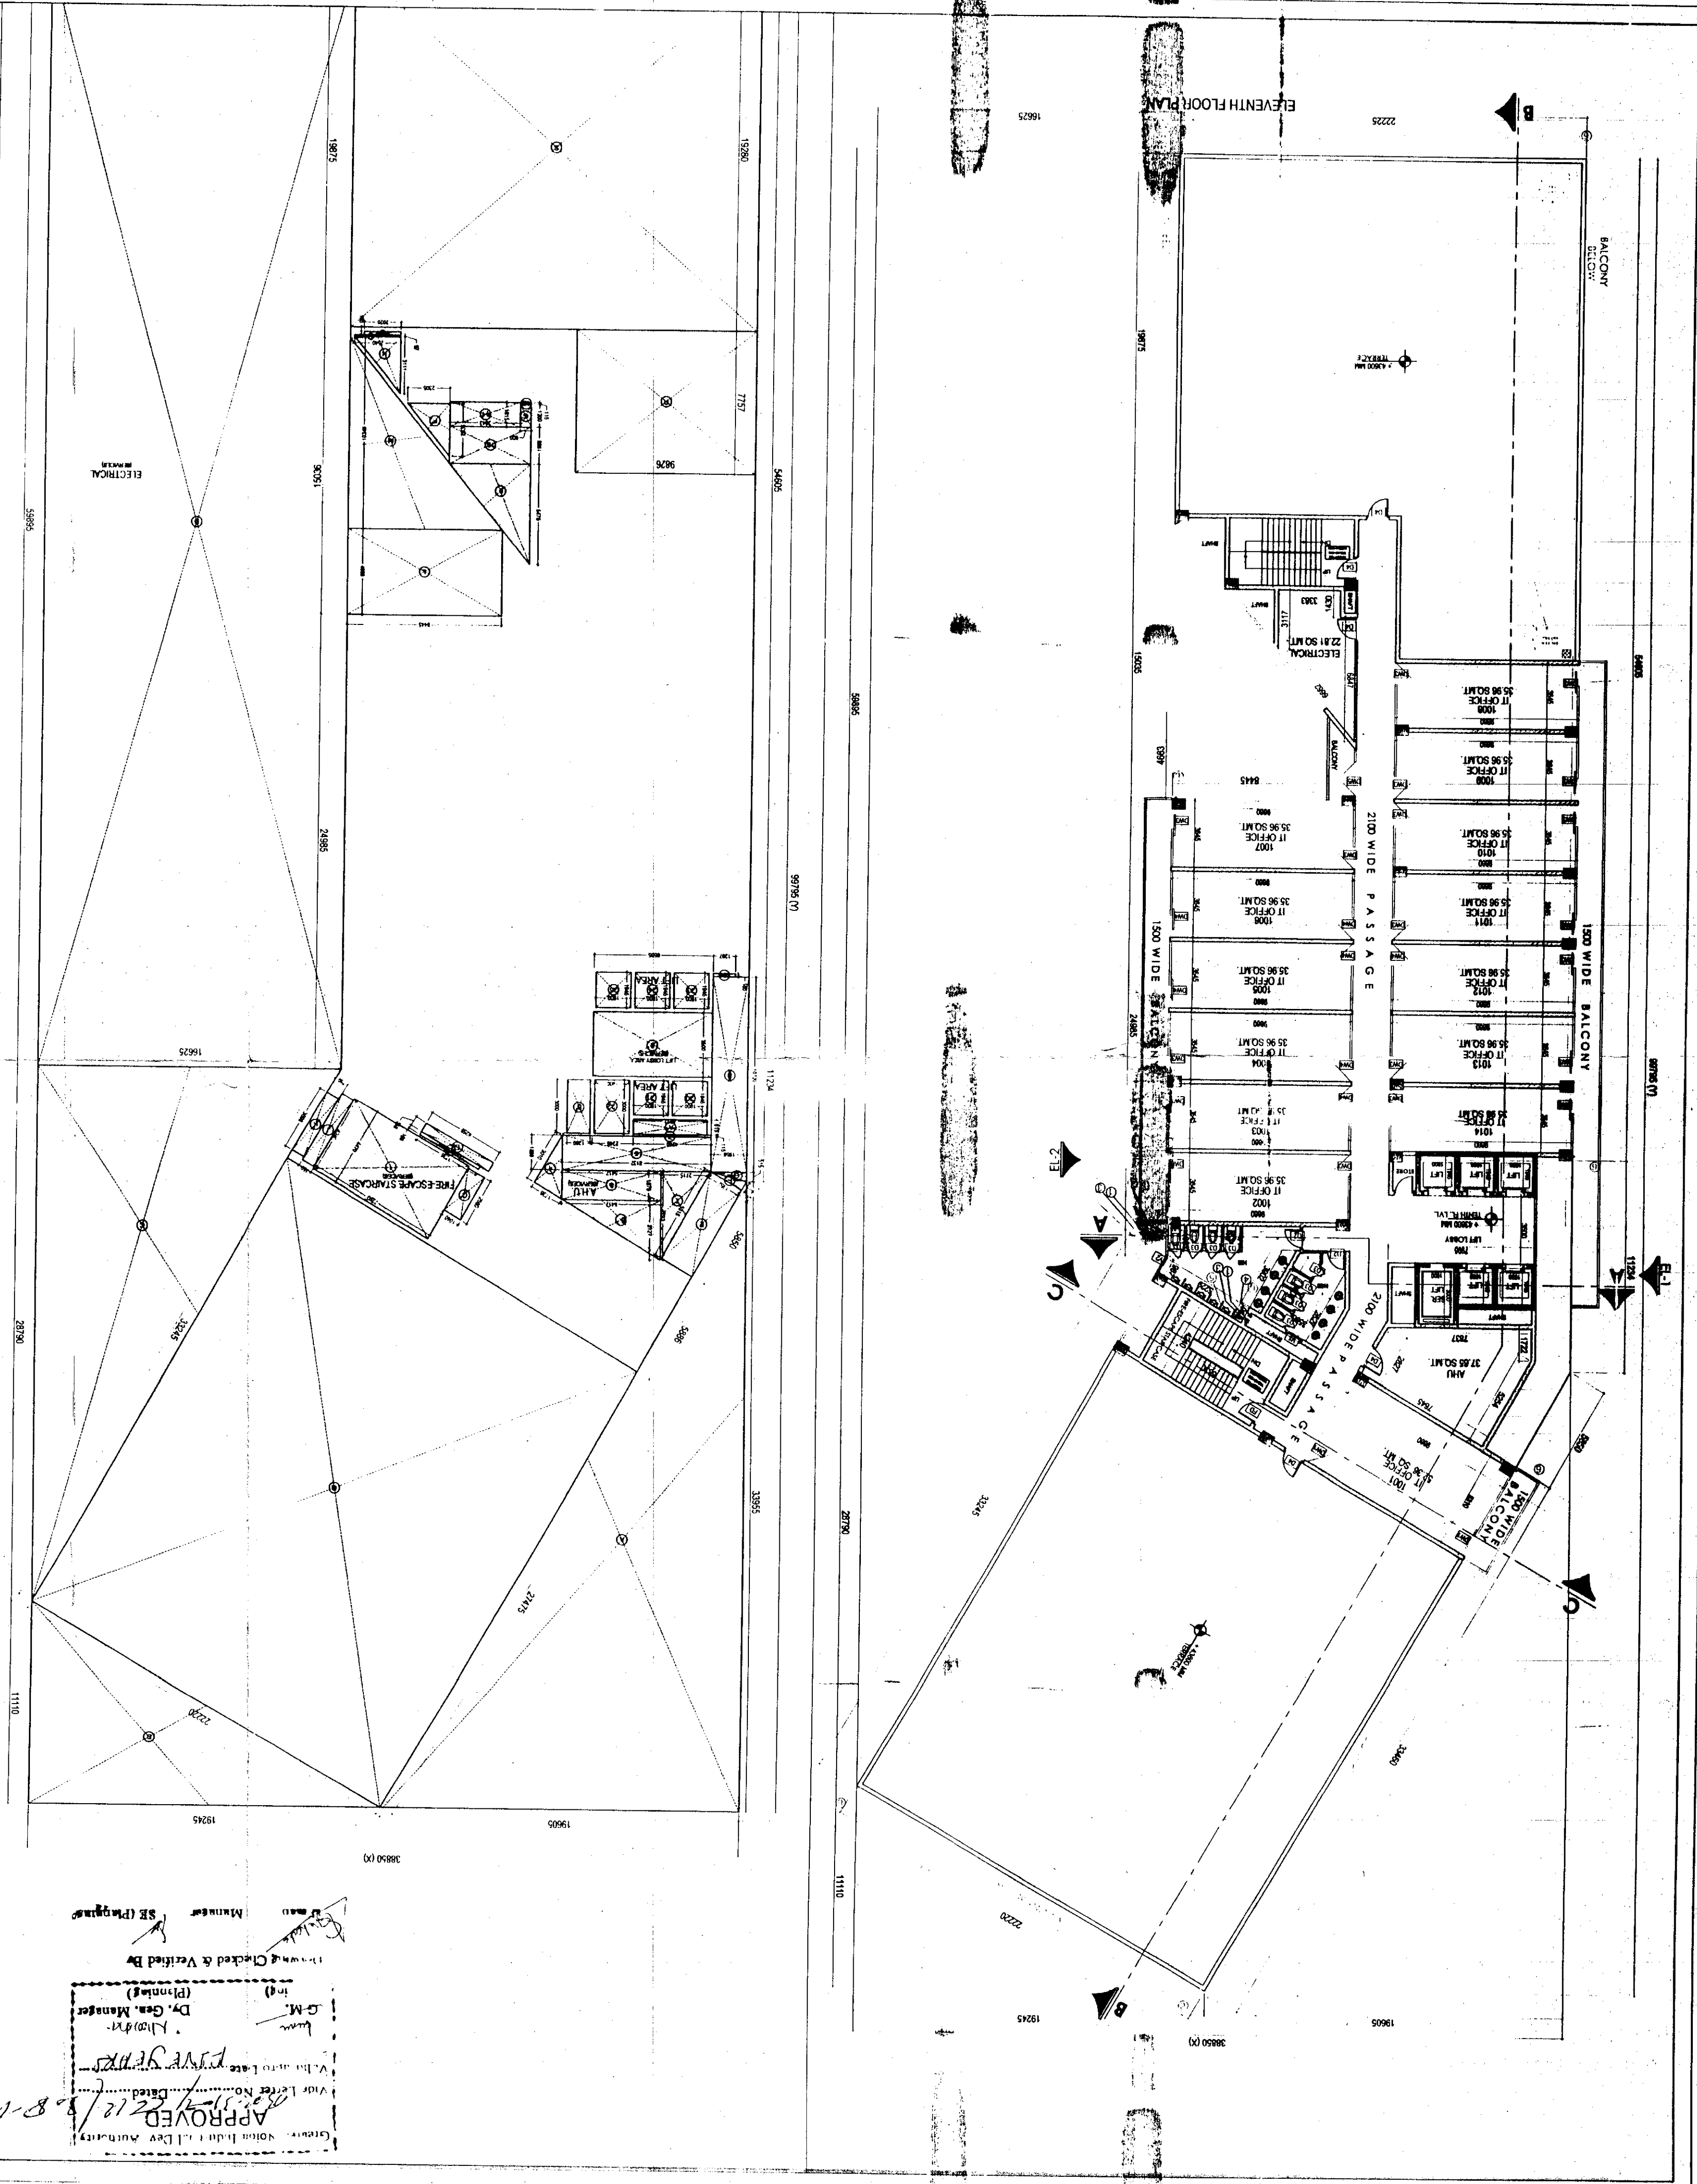

APPROVED
Date: 12/12/2018
By: [Signature]
For: [Signature]
Checked & Verified By: [Signature]
Dr. [Signature]
(Plumbing)

REVISION
R3
SCALE
1:150
NORTH

DRAWING NO.
1039/60/SUB/IT-11/PLAN/4

FOR SP SAI IT PVT. LTD.

Authorised Signatory

OWNER'S SIGNATURE

ARCHITECT'S SIGNATURE

REGISTERED ARCHITECT
CA/87/10461

ELEVENTH FLOOR PLAN
& AREA CALCULATION
IT-11

DRAWN BY: DOLLY SINGH

ACPL

ACPL Design Ltd
Architects
Planning
ISO 9001:2008