


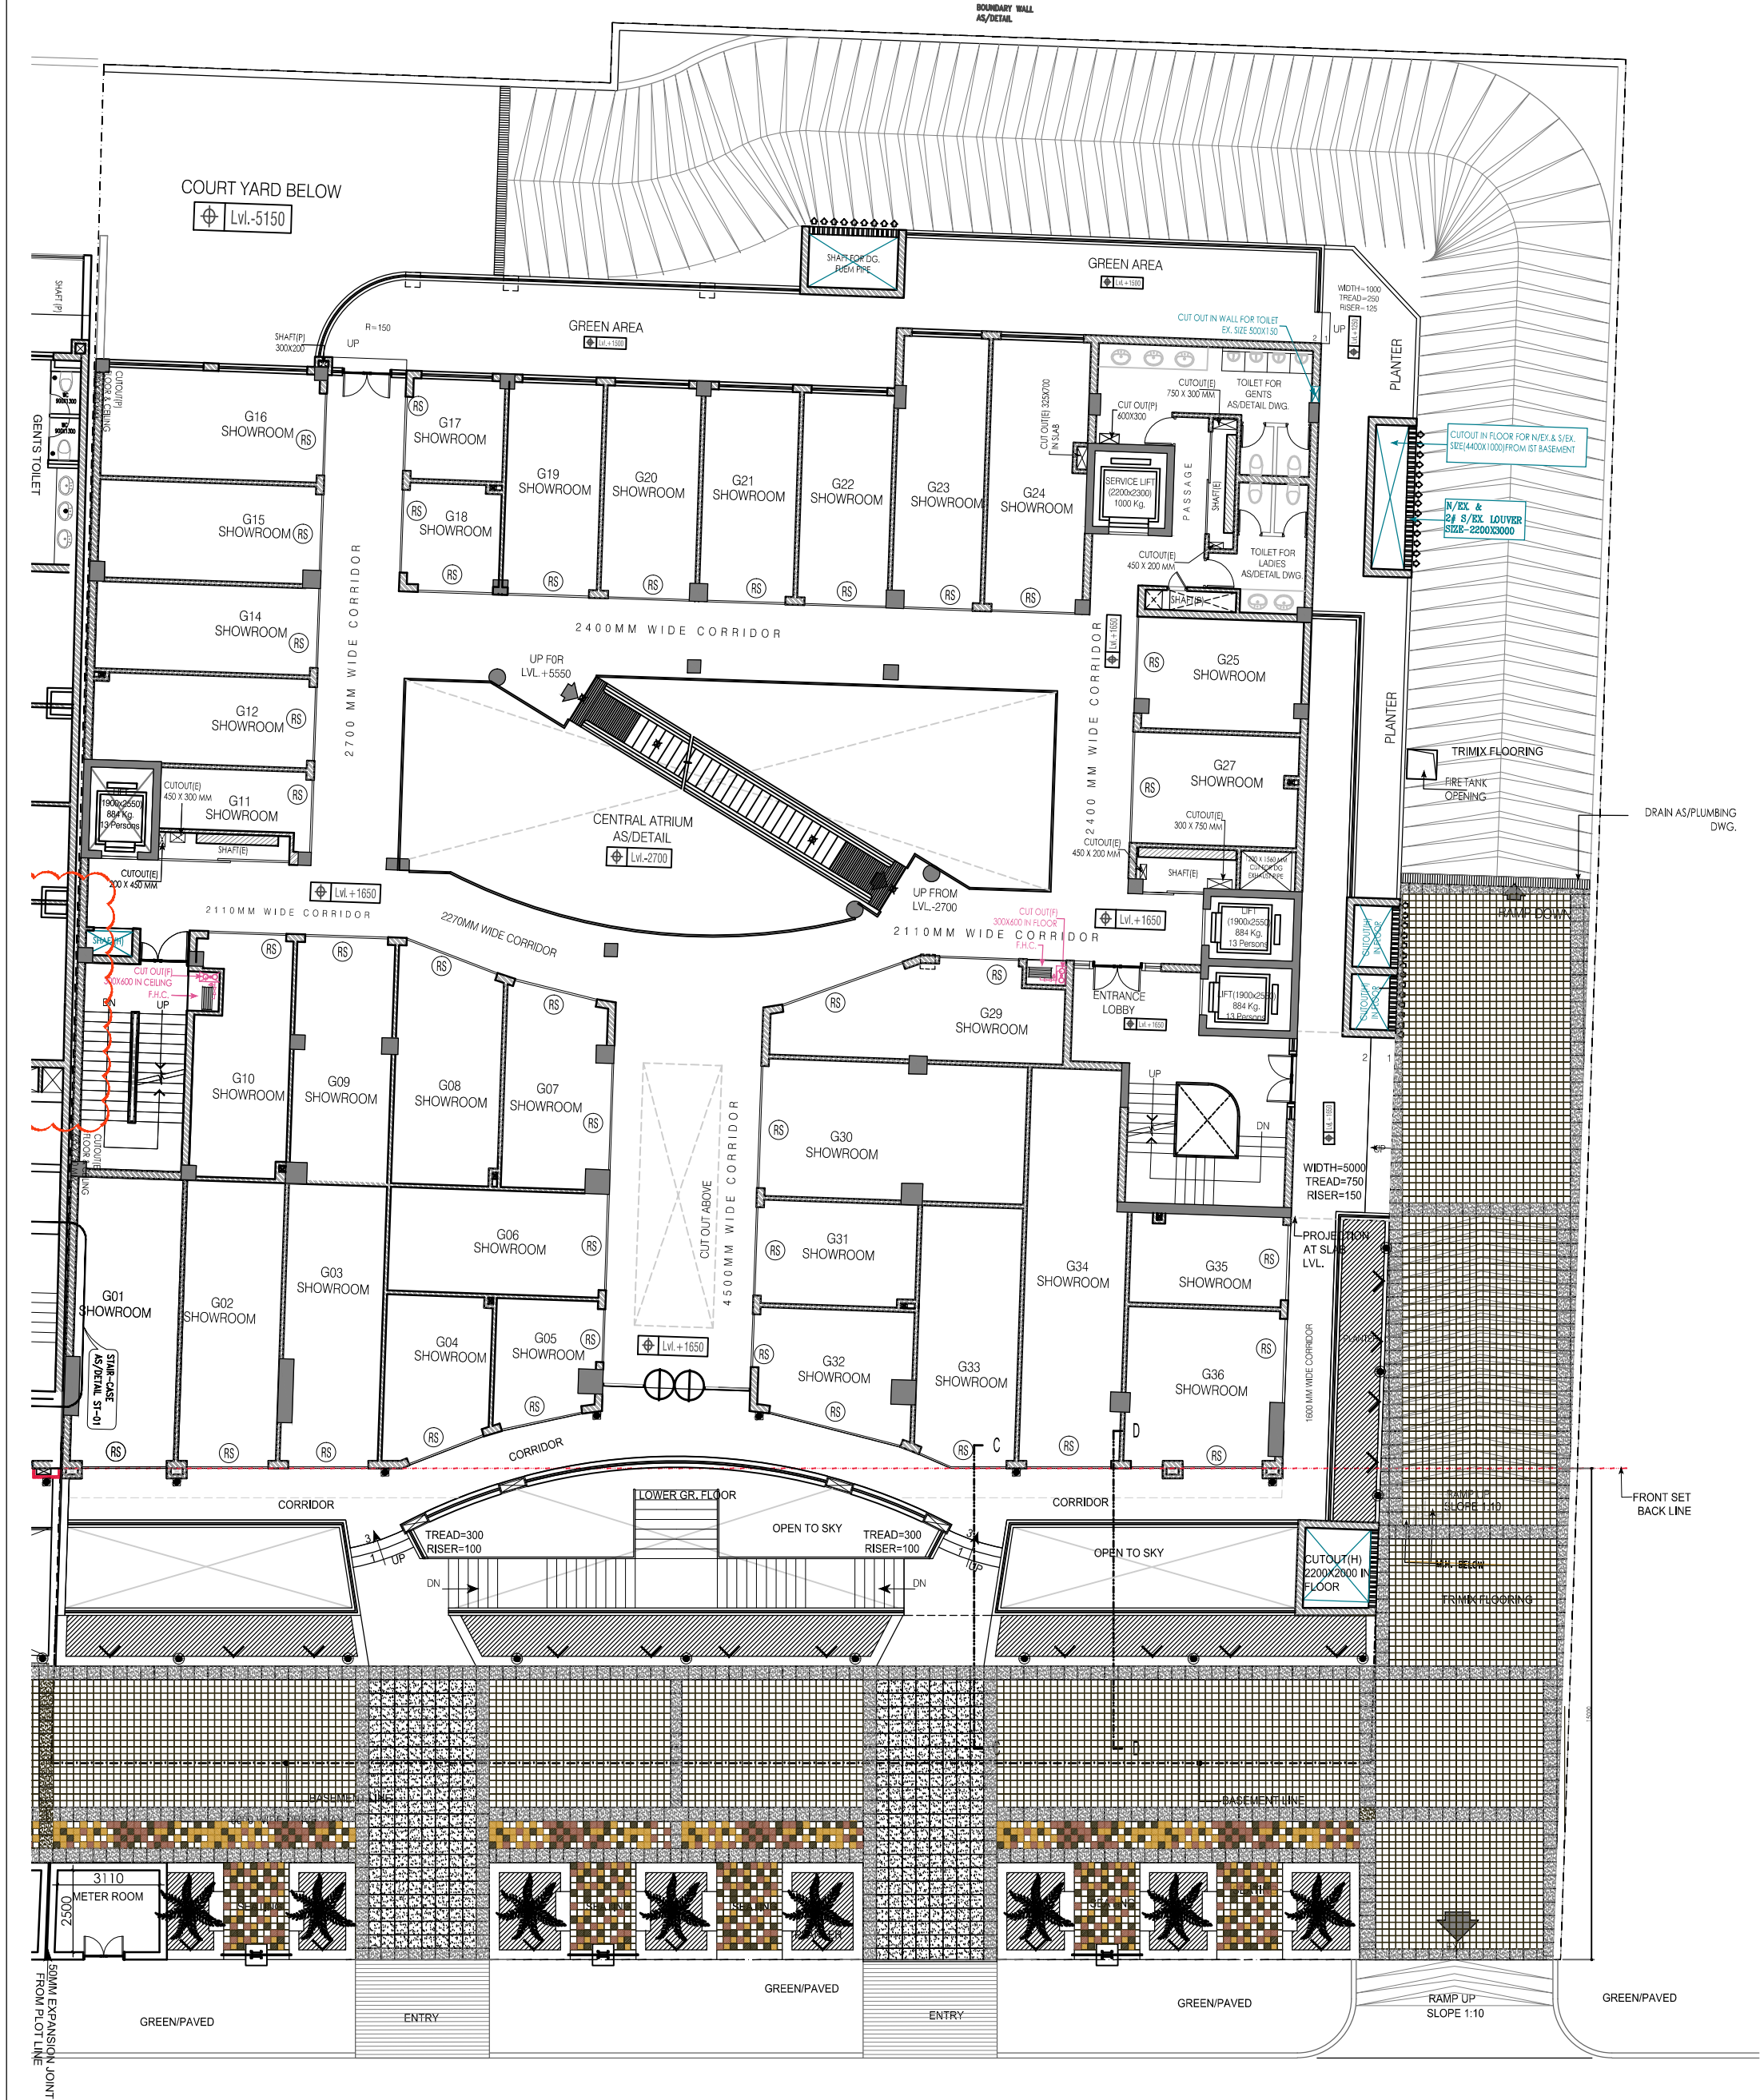

GROUND FLOOR PLAN

NOTES	Dimensions are not to be scaled. Contractor must verify all dimensions at site before commencement of any work. Contractor must notify Architect and/or Project Manager of all discrepancies in the drawing. All levels given are finished floor levels unless mentioned otherwise. Refer this drawing along with other relevant architectural structural & other services drawings, before the execution of work, related to this drawing or site.			HVAC. Consultant			Architects			Client			Drawing Title		
	No. Date By Description			SPC Engineers Pvt. Ltd. (Design Consultancy Project Management) 79, Samrat Enclave, Delhi-110034 Tel: 91-011-2710 6705, 2719 5456, 2719 5457 Fax: 91-011-27132522 E-Mail: spca@vsnl.com, spcengineers@eth.net			GIAN P. MATHUR & ASSOCIATES (P) LTD. ARCHITECTS, ENGINEERS & PLANNERS C-65, EAST OF KAILASH, NEW DELHI-110065 Ph: 011-46599599, 46599512 EMAIL: info@gminda.com Website: www.gminda.com			SAVIOURS BUILDERS PVT.LTD.			SECOND FLOOR PLAN (LVL.+9450)		
	No. Date By Description			ELEC. & PLUMB. Consultant			Key Plan			Project Code 1013			Status: --		
	No. Date By Description			Consummate Engineering Services (P) Ltd. A-48, Sector-52, Noida-201307 Tel: (0120) 4233044 / 4233033 Fax: (0120) 2395577 3/179, Vivek Khana, Gurgaon Nagar, Lucknow-226 910 Tel: (0522) 4005456 / 2395487 Fax: (0522) 2395487 e mail: mail@coneg.in						Project Title			Drawn: ANIL Checked: PARMINDER Date: - Scale: AS SHOWN		
	No. Date By Description			REVISIONS						SAVIOURS STREET CROSSINGS REPUBLIC AT GHAZIABAD, NH-24			Drawing No. 1013/SS/AD/06 Revisions: 01		