



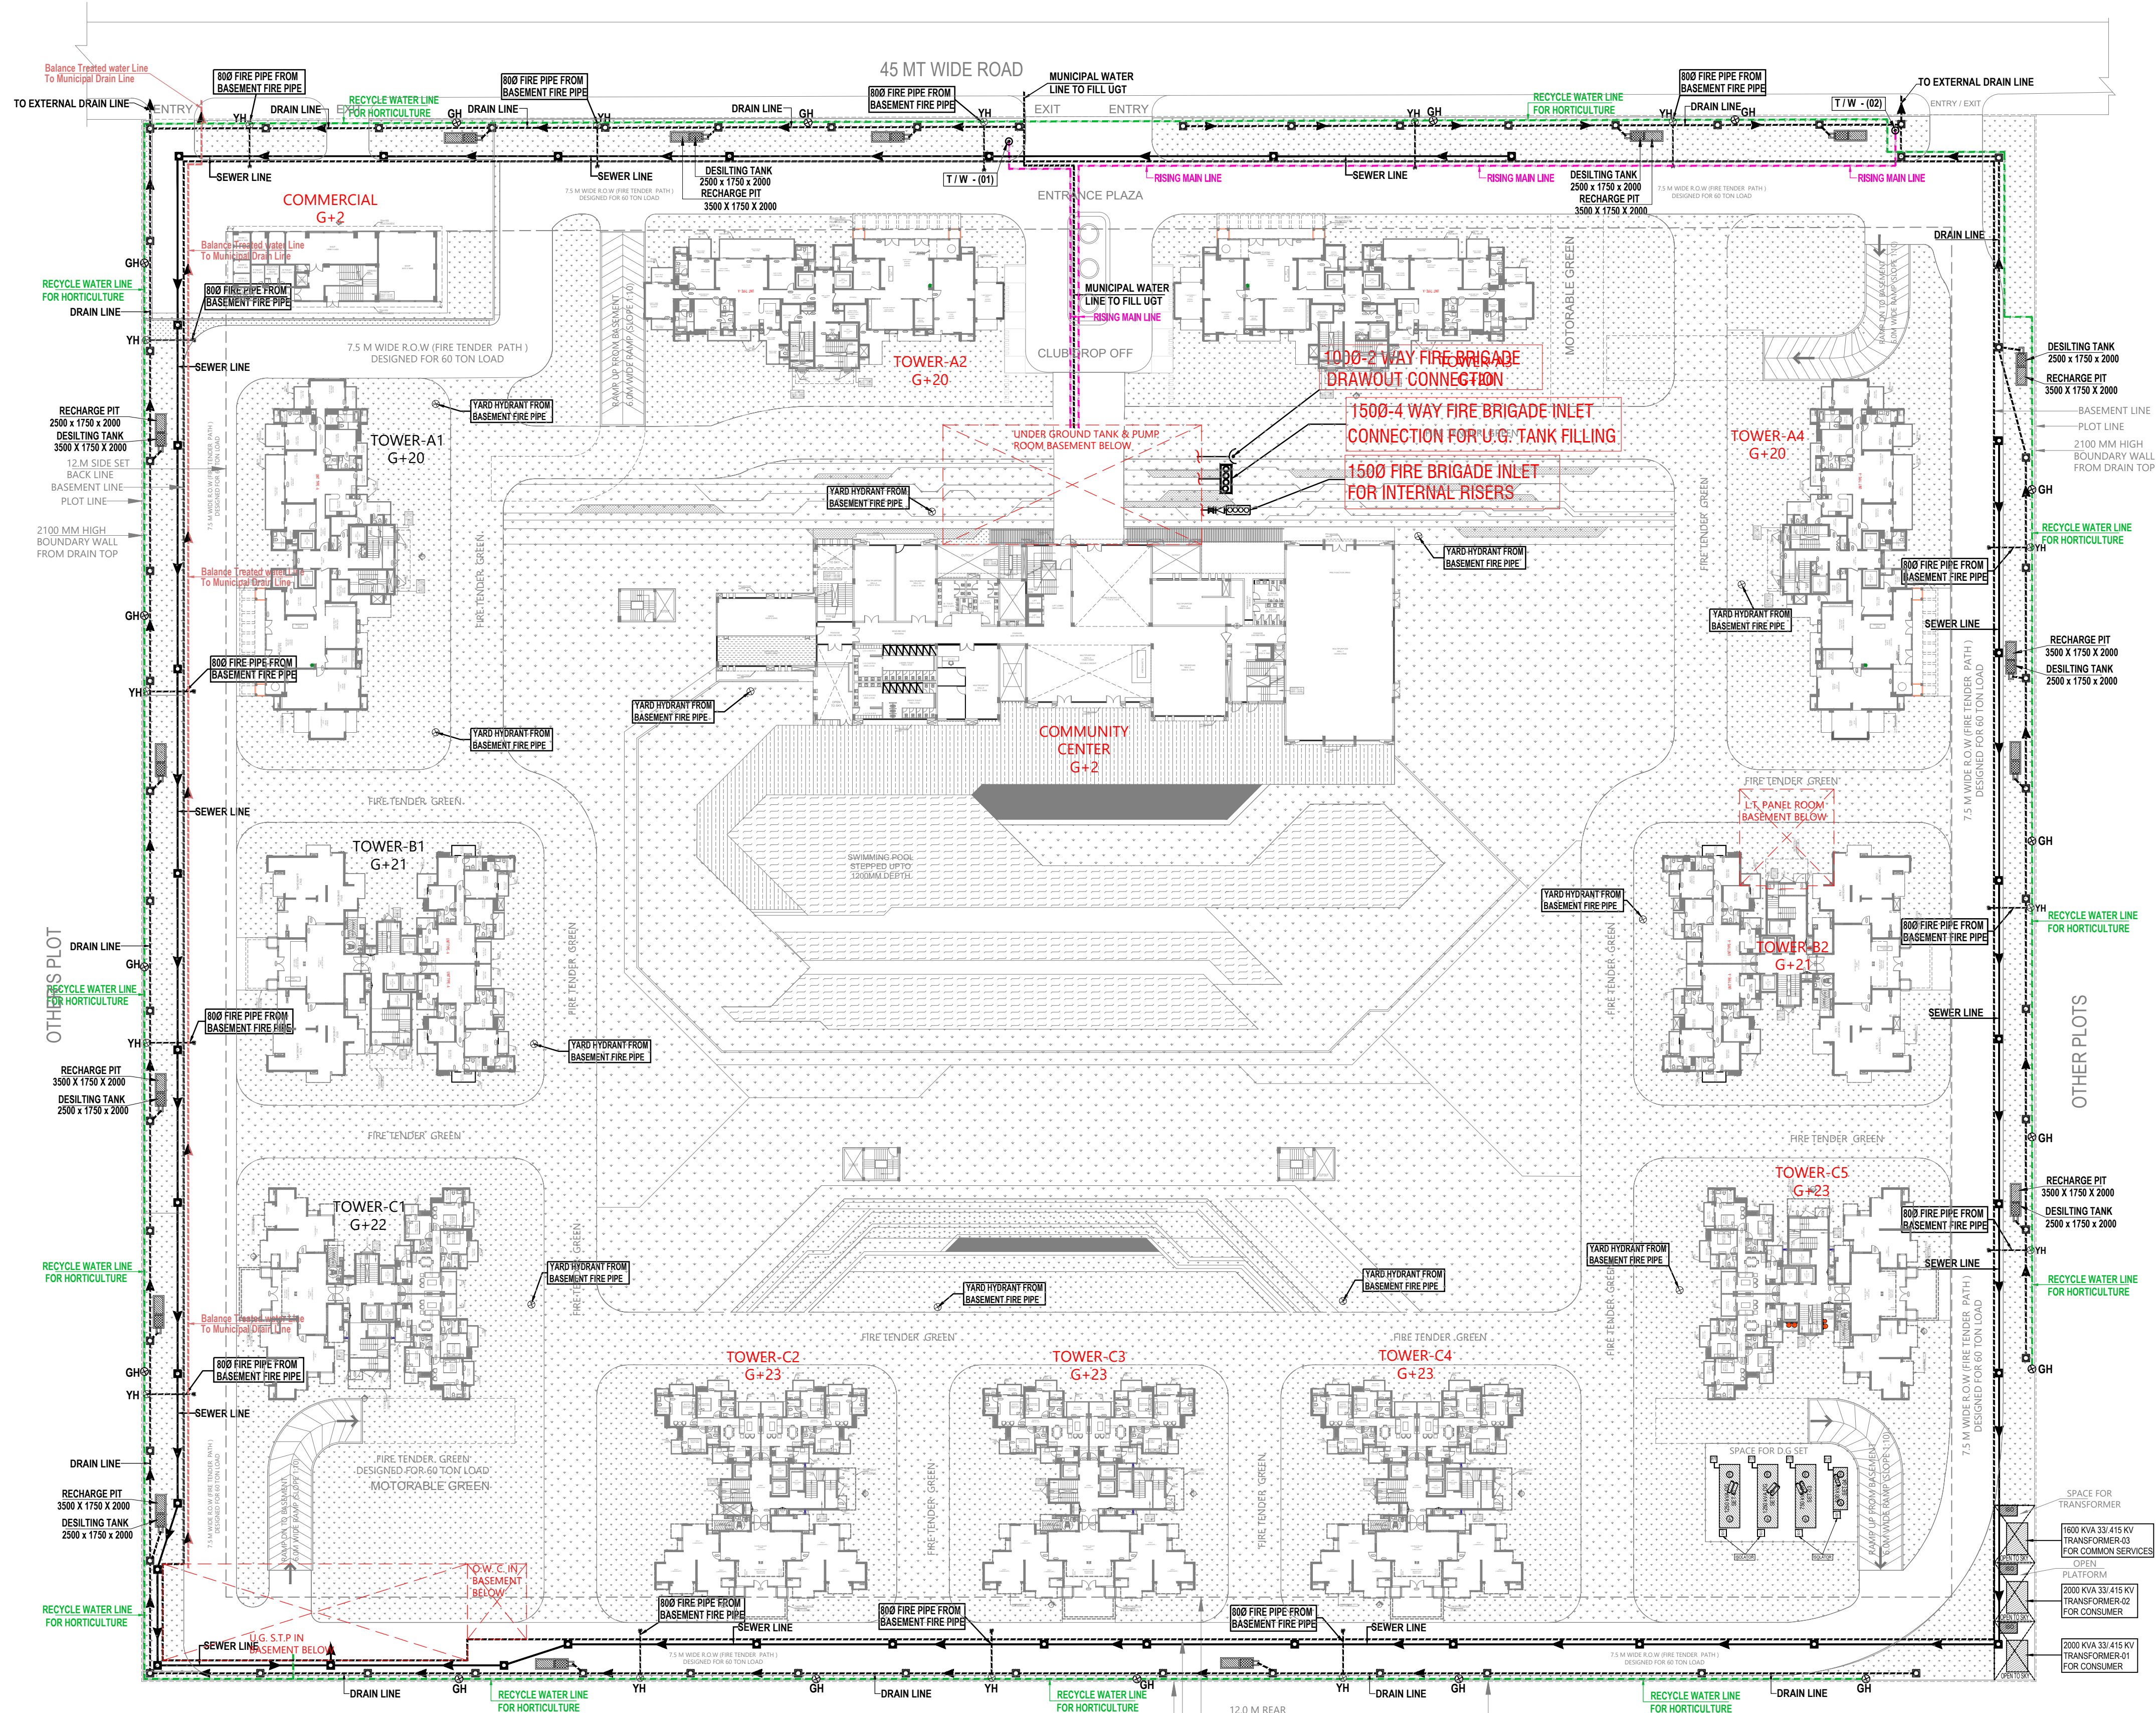

LEGEND :		
S. No.	SYMBOL	DESCRIPTION
1.	M.H. □	MANHOLE
2.	—	SEWER LINE
3.	---	BYPASS SEWER LINE
4.	C.P. □	CATCH PIT
5.	---	UNDER GROUND DRAIN
5.	■	RAIN WATER HARVESTING
8.	---	RECYCLED WATER SUPPLY PIPE LINE.
9.	---	RISING MAIN WATER PIPE LINE.
10.	---	MUNICIPAL WATER SUPPLY PIPE LINE.
11.	---	ISOLATING VALVE
12.	⊙	PROPOSED TUBE WELL
13.	---	BASEMENT LINE
14.	⊙GH	GARDEN HYDRANT

LEGEND : FIRE SYSTEM		
S. No.	SYMBOL	DESCRIPTION
1.	---	FIRE LINE
2.	YH	YARD HYDRANT 63 M.M. DIA. SINGLE HEADED HYDRANT VALVE WITH 2 NOS. 15 M. LONG, 63 M.M. DIA. FIRE HOSE PIPE & 1 NO. BRANCH PIPE WITH NOZZLE
3.	□	FIRE BRIGADE CONNECTION
4.	---	BUTTERFLY VALVE
5.	---	NONRETURN VALVE (CHECK VALVE)
6.	---	ISOLATING VALVE WITH MASONARY CHAMBER

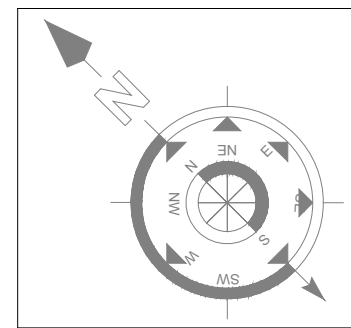

Rev. no.	Date	Revision

Project
PROPOSED GROUP HOUSING FOR M/S ACE INFRACTY DEVELOPERS PRIVATE LIMITED, AT PLOT NO:- SC-02/G, SECTOR - 150 NOIDA, (U.P.)

Title
SITE PLAN

Subtitle
EXTERNAL COMBINED SERVICES

Drawing released for
☐ APPROVAL ☒ SUBMISSION
☐ ADVANCE COPY ☐ CONSTRUCTION

Drg. no. ACE / EX / S-05 Drawn by Kulwant

Scale A1@ 1 : 550 Designed by R.K.

Date Feb. 2026 Checked by R.K.

Architects :
Confluence
NEW DELHI, INDIA
F-1, FIRST FLOOR
MINA CORPORATE SUITES,
ISHWAR NAGAR D-45, INDIA
architecture urban design hospitality interiors
Ph: +91-11-41684608 con@confluence.com Member of: ICSC
CA-8023281 www.confluence.com ISO - 9001:2000

services consultant
Cespi Consultants Pvt. Ltd.
Noida Office : B - 67, Sector - 67, Noida - 201 301
Tel : (0120) 3225400 / 3225401
e mail : mail@cespin, website : www.cespin



For ACE Infraction Pvt. Ltd.

