




LANDSCAPE CALCULATION						
S. NO	TYPE	LENGTH	WIDTH	NO'S	TOTAL	UNIT
1	L1	6000	100085	2	1201.02	SqMt.
2	L2	97095	3000	1	291.285	SqMt.
3	L3	3600	3900	2	28.08	SqMt.
4	L4	54900	6900	1	378.81	SqMt.
5	L5	5000	1880	1	9.40	SqMt.
6	L6	8710	8550	1	74.4705	SqMt.
8	L7	19635	8550	1	167.88	SqMt.
9	L8	10315	8550	1	88.19325	SqMt.
10	L9	8230	10000	1	82.30	SqMt.
11	L10	19265	22000	1	423.83	SqMt.
12	L11	10230	15540	1	158.97	SqMt.
13	L12	14800	10540	1	155.99	SqMt.
14	L13	12010	1500	1	18.02	SqMt.
15	L14	11795	6285	1	74.13	SqMt.
16	L15	7930	6285	1	49.84	SqMt.
TOTAL LANDSCAPE AREA PROVIDED					3078.25	SqMt.
TOTAL LANDSCAPE AREA REQUIRED					25% OF TOTAL PLOT AREA	
TOTAL LANDSCAPE PROPOSED					3078.25	SqMt.

SUBMISSION DRAWING

PROJECT:
1BHK & 3BHK APARTMENTS,
PLOT NO. L & M SECTOR - 12
AT GREATER NOIDA.

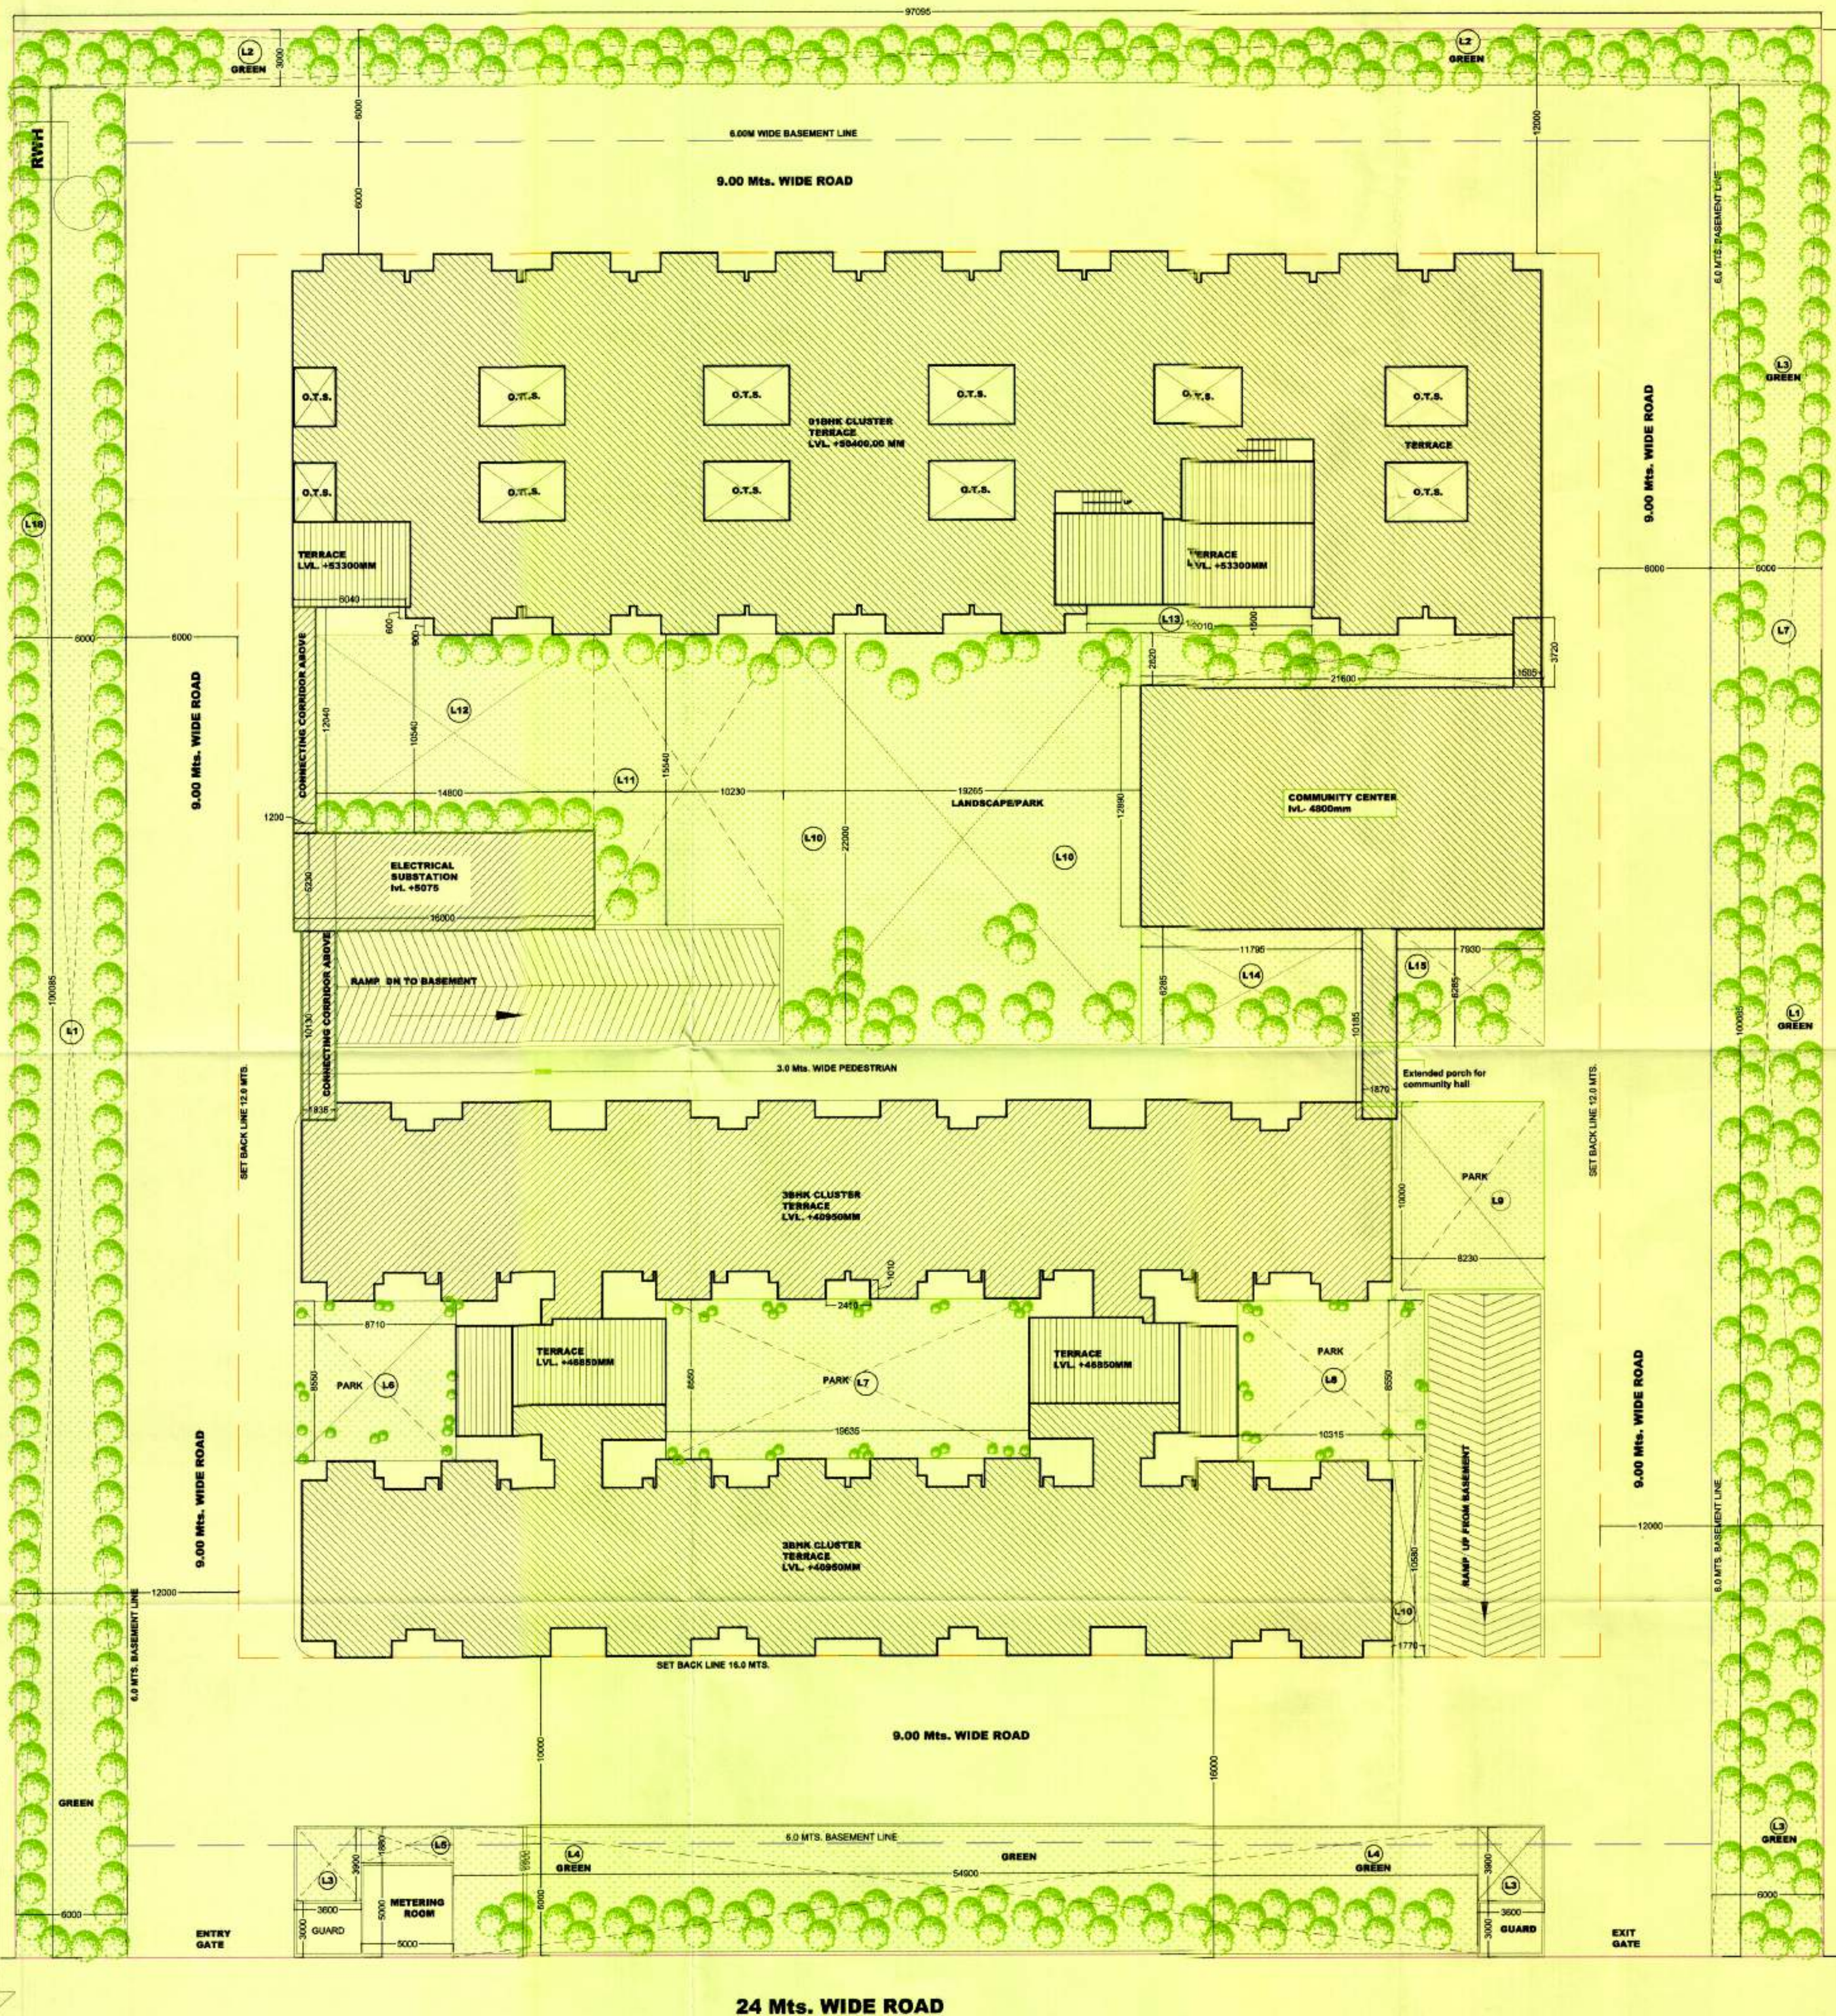

COMMERCIAL BELT

130 M WIDE ROAD

KEY PLAN (NTS)

LEGEND:

SITE BOUNDARY

SETBACK

BASEMENT LINE

CONSTRUCTION AGENCY :

GREATER NOIDA INDUSTRIAL DEVELOPMENT
AUTHORITY,
169 CHITVAN ESTATE SECTOR
GAMMA - II GREATER NOIDA, GAUTAM BUDDH
NAGAR, UTTAR PRADESH 201308

DRG. TITLE:

SITE PLAN &
LANDSCAPE AREA CALCULATION

REVISIONS :			
S.N.	REVISION	DATE	DESCRIPTION

DATE:	SCALE:	NORTH:	DRG NO.:
JULY 2017	1:200		LP-02



CONSULTING ARCHITECTS:
ARCH-EN DESIGN

Architect **ASHOK KUMMAR**

DELHI OFF: B-16, HALU KHAS, NEW DELHI-16.
011-45188222, Fax: 011-45188288

LUCKNOW OFF: 45 VISHAL KHAND, GOMTI NAGAR, LUCKNOW
0522-4088222, Fax :- 0522-4088288


Ashok Kumar
ASHOK KUMMAR
S. ARCH. A.I.A. A.I.I.D.
REGD. No. CA/8418075
B1/37, GROUND FLOOR, HALU KHAS
NEW DELHI-16 Ph: 011-45188222

ACEO

CEO

SURESH KUMAR SR. DVMAN W. SUKHEER SR. EXE. (PLNG.) NIMISHA SHARMA D.G.M. (PLNG.) G.M. (PLNG./ARCH.)

**GREATER NOIDA INDUSTRIAL
DEVELOPMENT AUTHORITY**

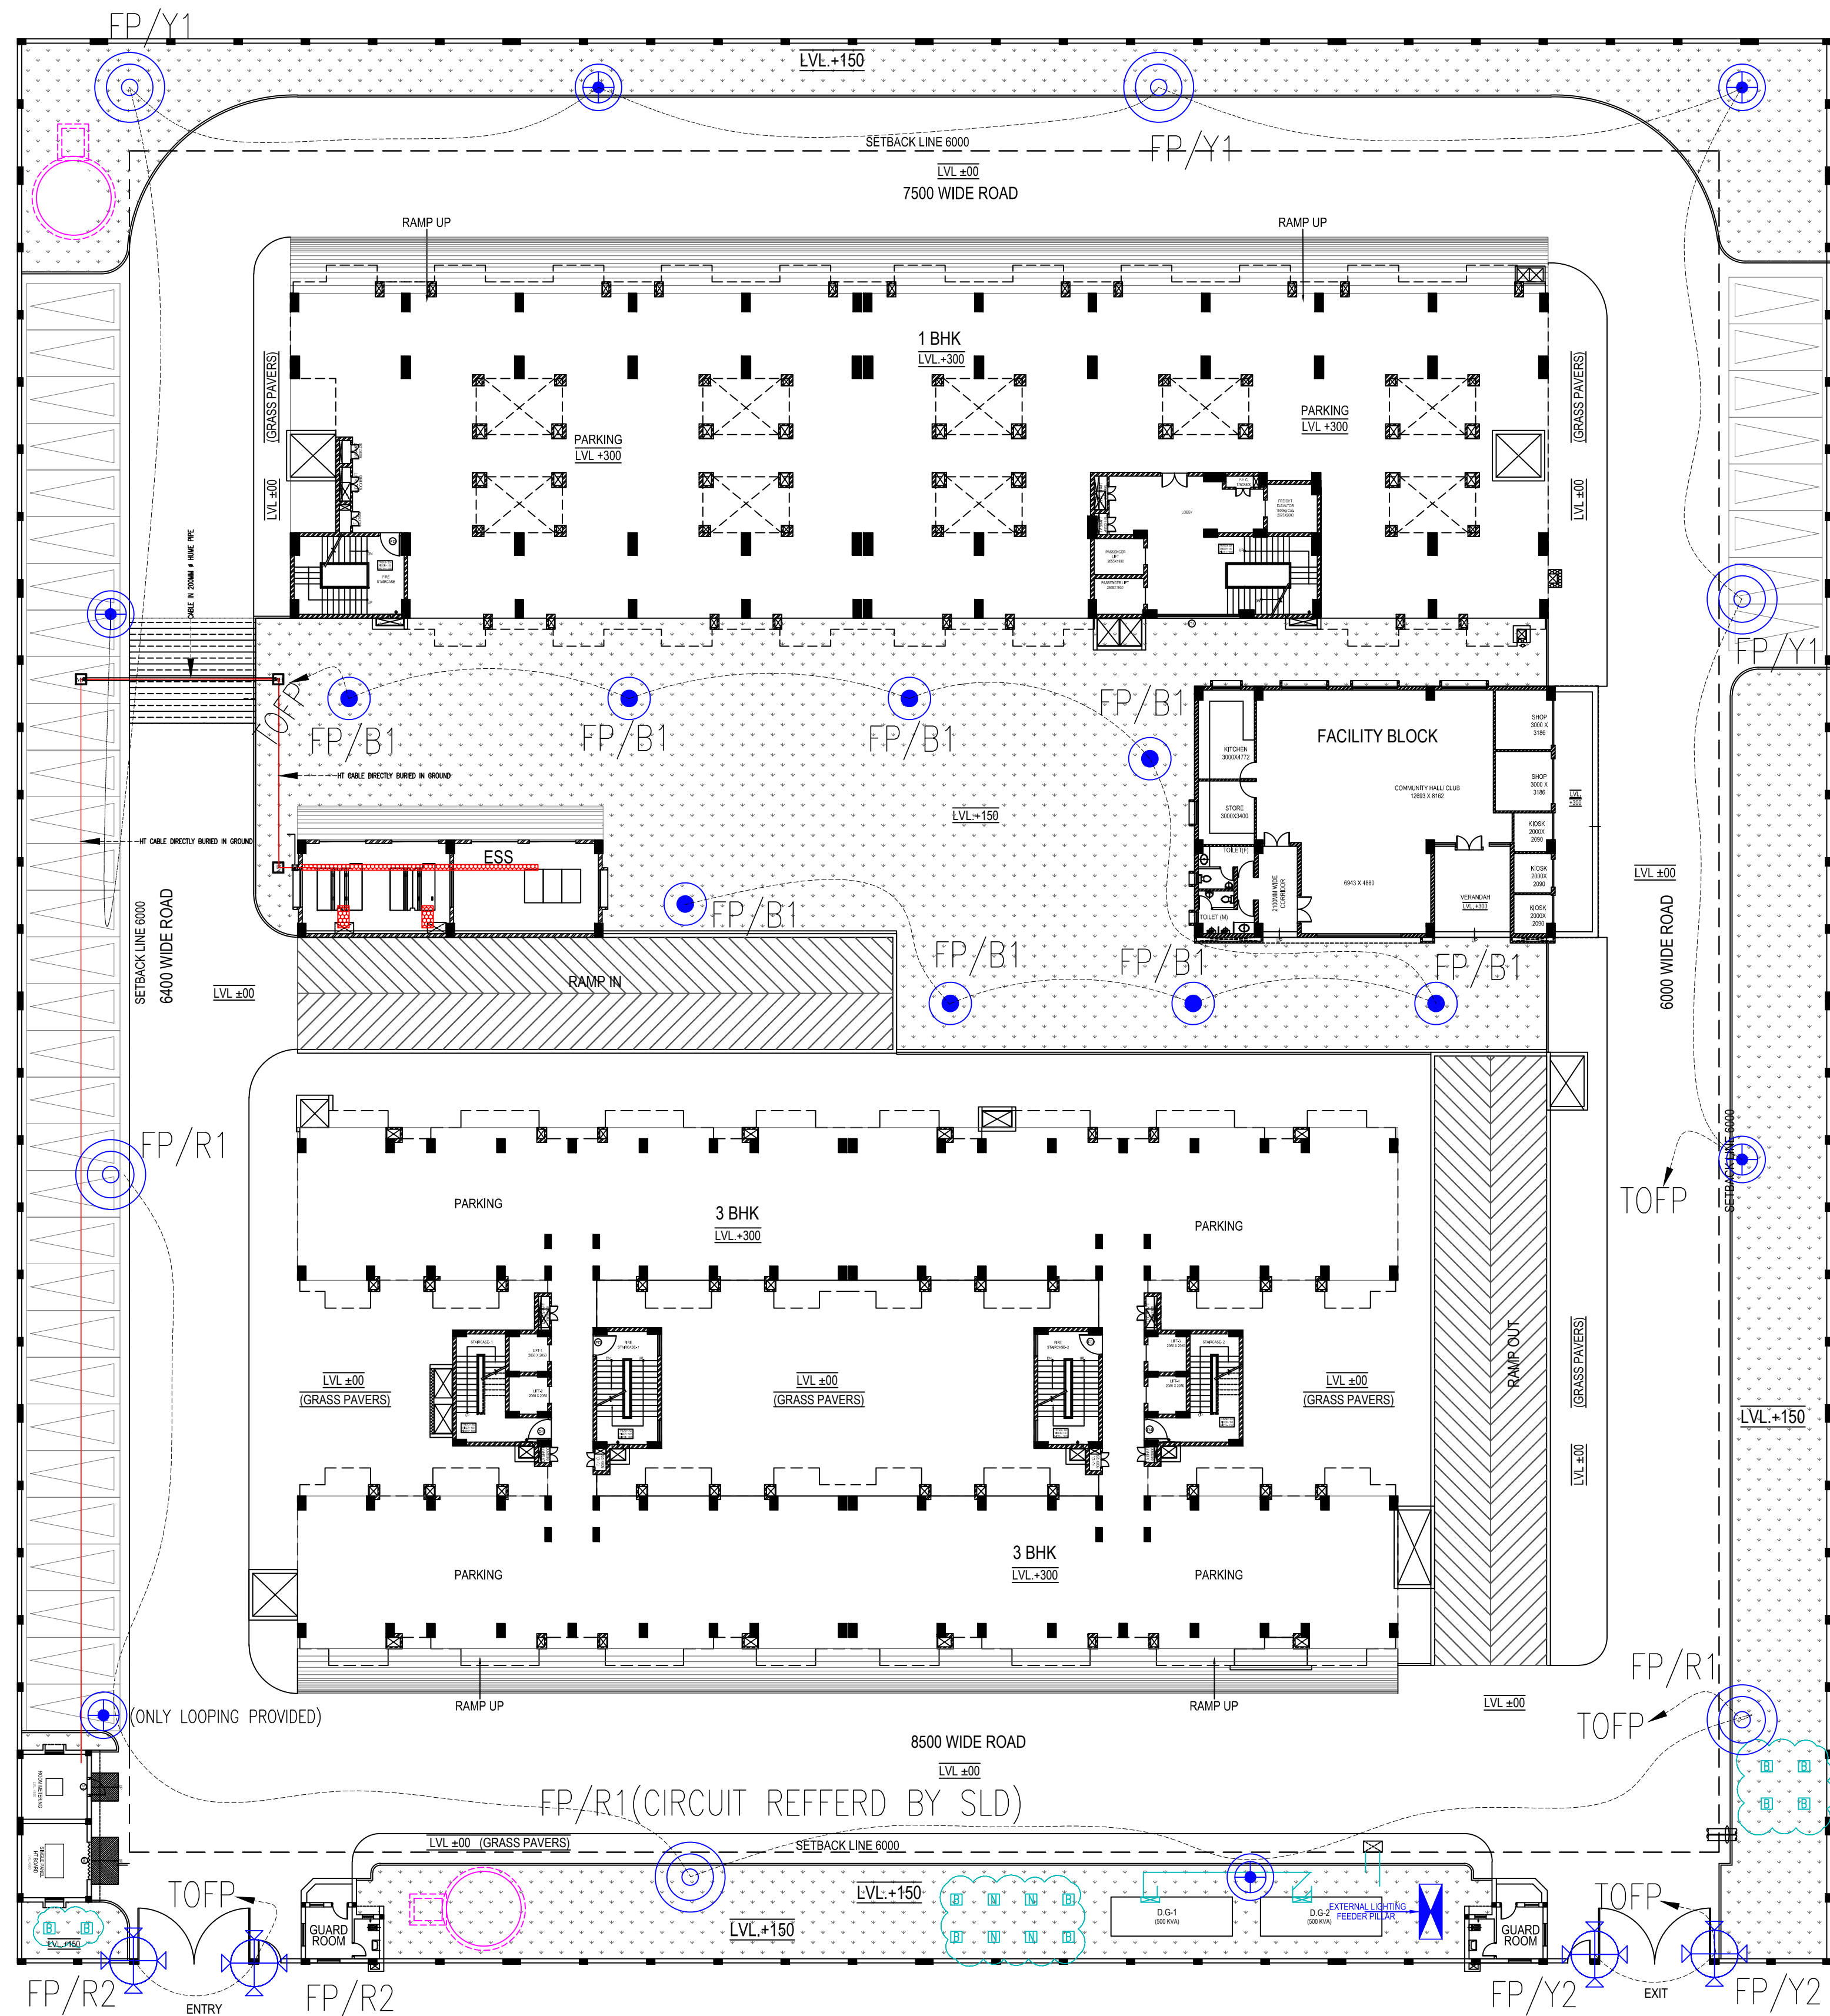

ELECTRICAL LEGEND		
1.		8Mtr BRIKA POLE WITH 78W LED LIGHT WITH SOLLAR BECKUP
2.		8Mtr BRIKA POLE WITH 78W LED LIGHT
3.		POST TOP LANTERN (BAJAJ BJMPTI 70SV LPF)
4.		4Mtr POLE WITH POST TOP LIGHT
5.		FEEDER PILLAR

NOTE-

- 1) ALL ITEMS SHALL BE APPROVED BY ARCHITECT.
- 2) LUX CALCULATION SHEET SHALL BE PROVIDED BY OEM FOR APPROVAL.
- 3) EXTERNAL LIGHTING FEEDER PILLAR SHALL BE ADVANCE PANELS & SWITCHGEAR / ABB / SIEMENS/ L&T MAKE .
PANEL SHALL BE MANUFACTURE AT THEIR RESPECTIVE PLANTS, AUTHORIZED INTEGRATORS SHALL NOT ALLOWED.
- 4) SHOP DRAWING WITH PROPER DIMENTION SHALL BE PROVIDED BY ELECTRICAL CONTRACTOR FOR APPROVAL.
- 5) PRIOR INSPECTION OF ELECTRICAL ITEMS SHALL BE DONE AT THEIR MANUFACTURING PLANT BY ELECTRICAL CONSULTANT.

SUBMISSION DRAWING

PROJECT:
**1BHK & 3BHK APARTMENTS ,
PLOT NO. L & M SECTOR - 12
AT GREATER NOIDA**

CONSTRUCTION AGENCY :
GREATER NOIDA INDUSTRIAL DEVELOPMENT
AUTHORITY,
169 CHITVAN ESTATE SECTOR
GAMMA - II GREATER NOIDA, GAUTAM BUDH
NAGAR, UTTAR PRADESH 201308

DRG. TITLE:
EXTERNAL LIGHTING LAYOUT
SITE PLAN

DRAWN BY:
SANJAY

CHECKED BY:
PRASHANT SHARMA

DATE:
07-04-2017

SCALE :
NTS

DRG NO. :
EL-SAGN-101C(EXT.)

REVISIONS :

S.N.	REVISION	DATE	DESCRIPTION
2)	R2	07.04.17	LIGHTING & HUME PIPE REVISED.
1)	R1	20.07.16	CIRCUITING REVISED

DATE:
JULY'16

SCALE :
NTS


NORTH :

DRG NO. :
EL-101C

CONSULTING ARCHITECTS:
ARCH-EN DESIGN
Architect **ASHOK KUMMAR**
DELHI OFF.: B-2/7, HAUZ KHAS, NEW DELHI-16.
011-45188222, Fax:- 011- 45188288
LUCKNOW OFF.: 4/S,VISHAL KHAND,GOMTI NAGAR, LUCKNOW
0522-4088222, Fax :- 0522- 4088288

A.C.E.O.		C.E.O	
SURESH KUMAR SR. DRAFT MAN	W. SUKHBIR SR.EXE.(PLNG.)	NIMISHA SHARMA D.G.M. (PLNG.)	G.M.(PLNG./ARCH.)

**GREATER NOIDA INDUSTRIAL
DEVELOPMENT AUTHORITY**

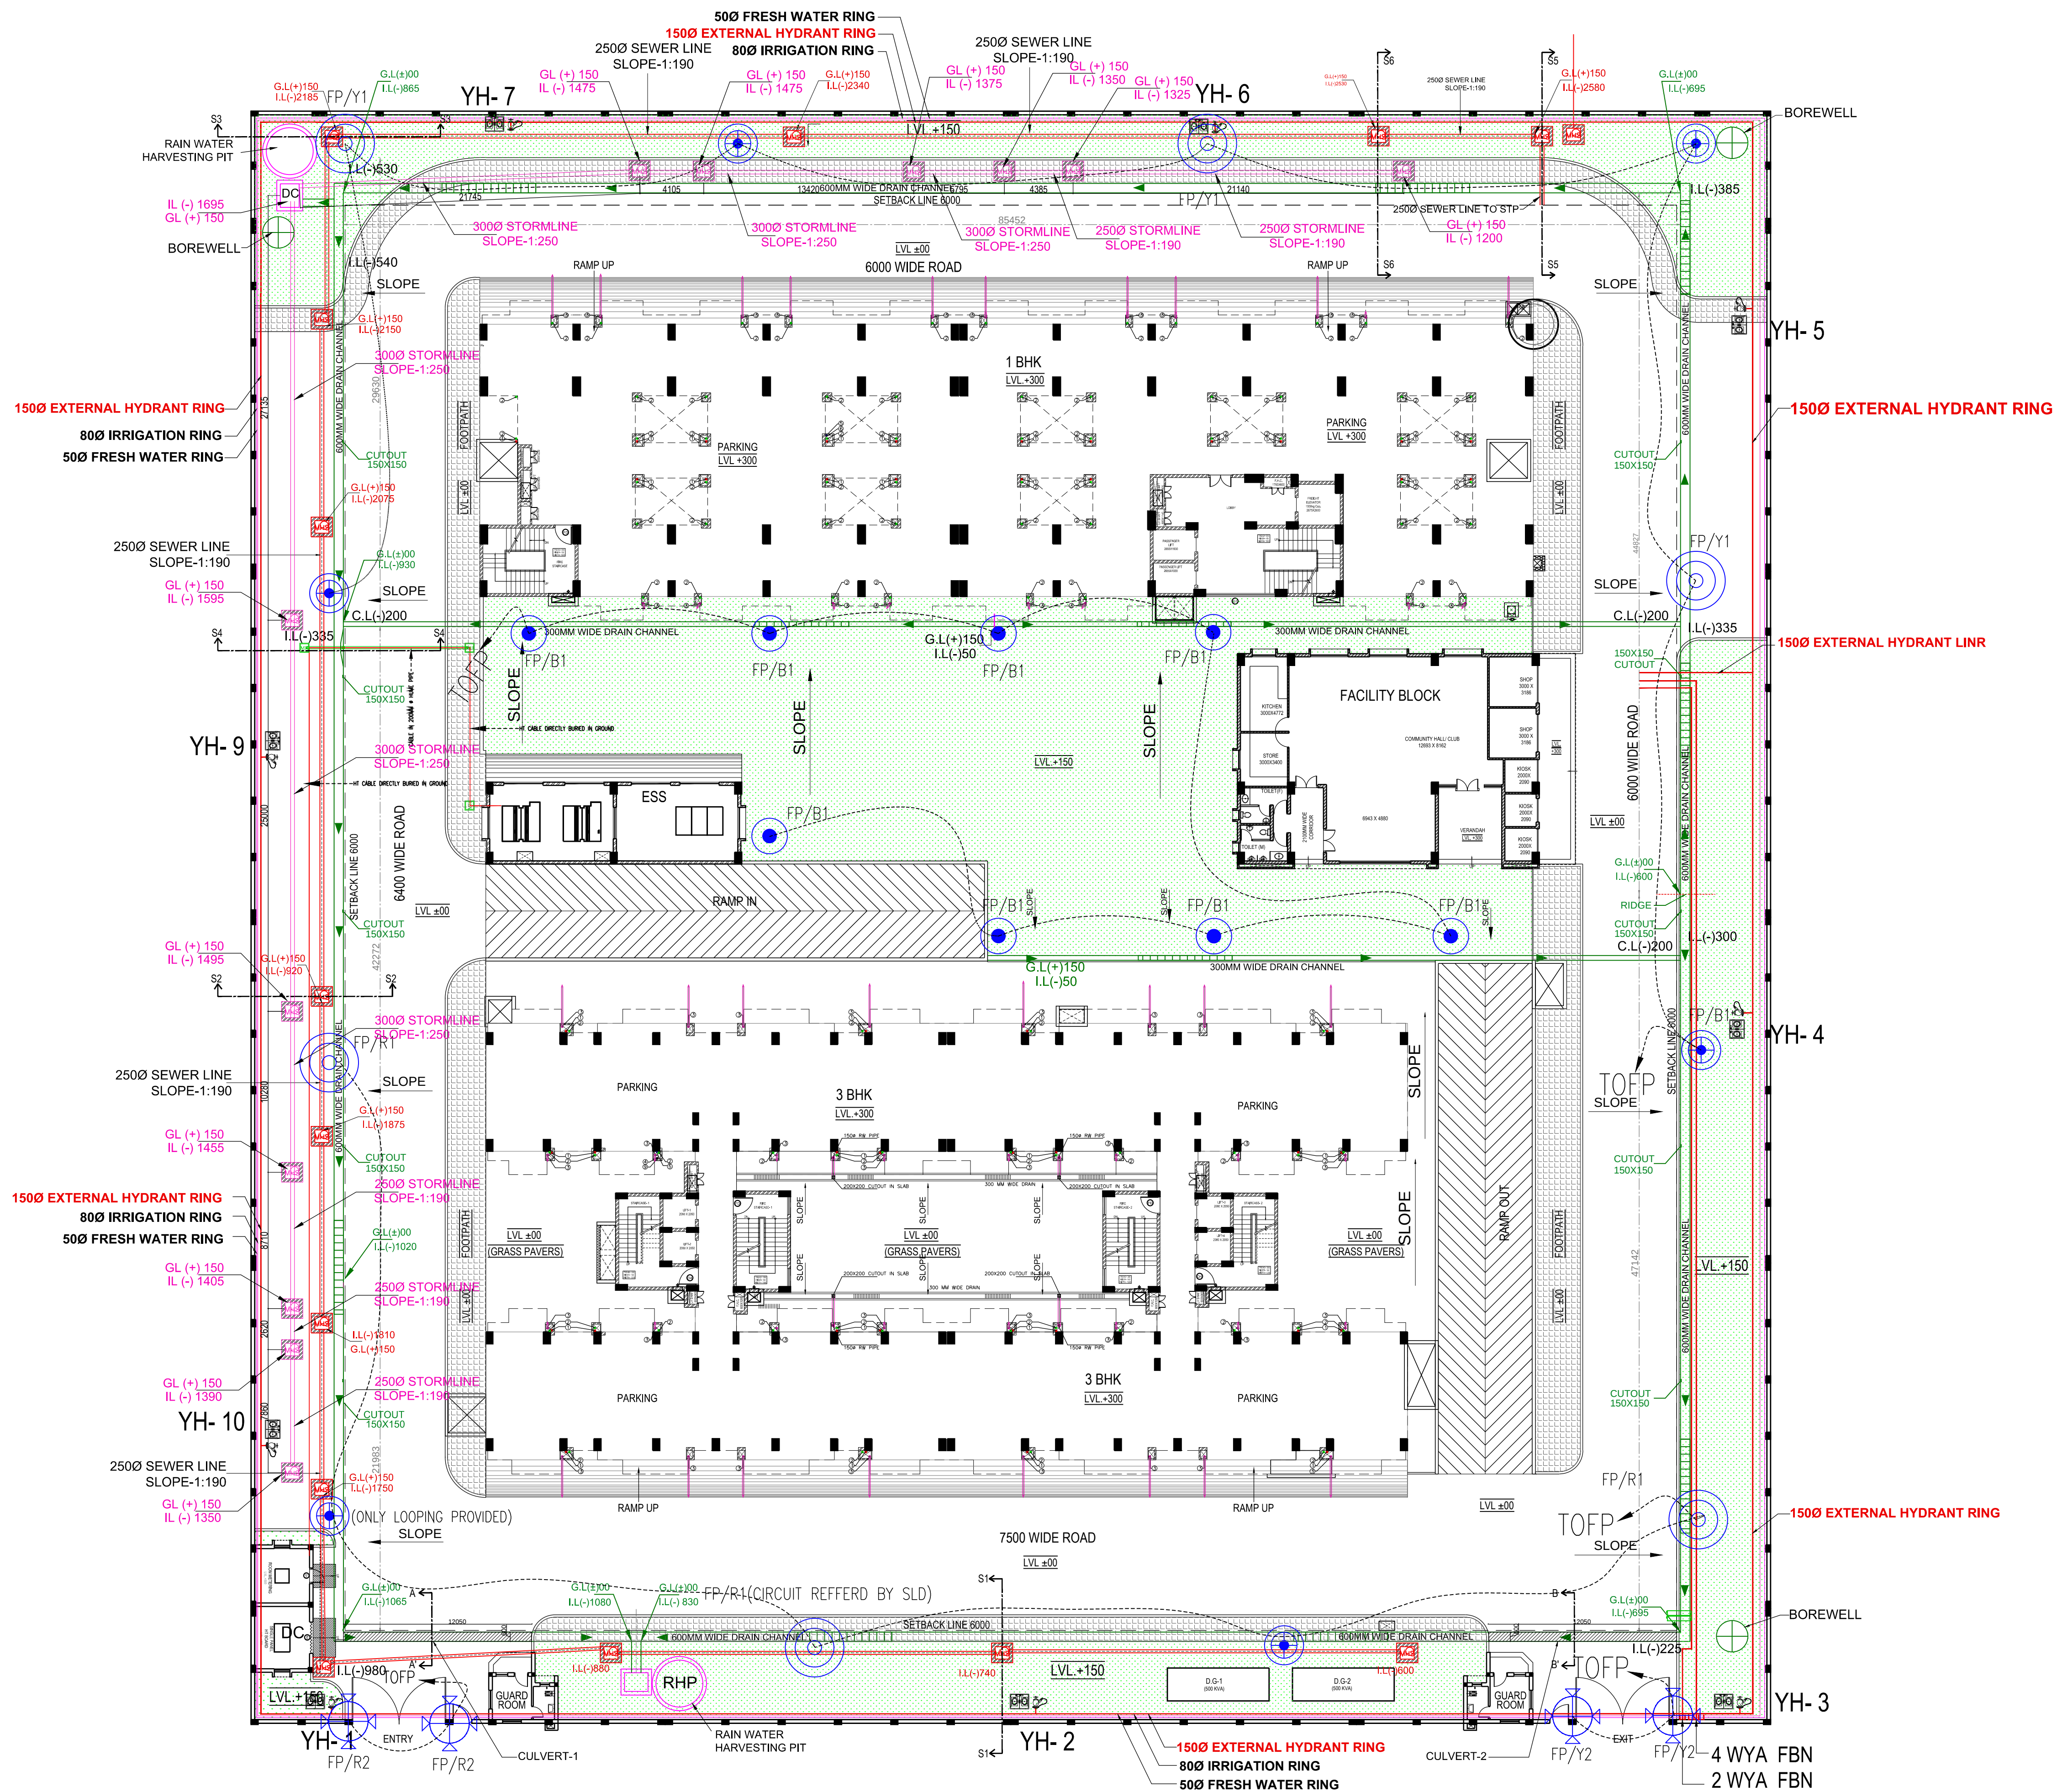

SUBMISSION DRAWING

PROJECT:

1 BHK & 3 BHK APARTMENTS,
PLOT NO. L & M, SECTOR- 12
AT GREATER NOIDA

CONSTRUCTION AGENCY :

GREATER NOIDA INDUSTRIAL DEVELOPMENT
AUTHORITY,
169 CHITVAN ESTATE SECTOR
GAMMA - II GREATER NOIDA, GAUTAM BUDH
NAGAR, UTTAR PRADESH 201308

DRG. TITLE:

EXTERNAL DEVELOPMENT PLAN

REVISIONS :			
S.N.	REVISION	DATE	DESCRIPTION

DATE:	SCALE:	NORTH :	DRG NO. :
APR-2017	1:100		AR-01A

AED

CONSULTING ARCHITECTS:
ARCH-EN DESIGN

Architect **ASHOK KUMMAR**

DELHI OFF.: B-26, HAUZ KHAS, NEW DELHI-16.
011-45188222, Fax:- 011-45188288

LUCKNOW OFF.: 45, VISHAL KHAND, GOMTI NAGAR, LUCKNOW
0522-4088222, Fax :- 0522- 4088288

A.C.E.O.		C.E.O.	
SURESH KUMAR SR. DRAFT MAN	W. SUKHBIR SR. EXEC.(PLNG.)	NIMISHA SHARMA D.G.M. (PLNG.)	G.M. (PLNG./ARCH.)

**GREATER NOIDA INDUSTRIAL
DEVELOPMENT AUTHORITY**

